



PARTIAL R/R/ PLUMBING PLAN
SCALE: 1/4" = 1' - 0"

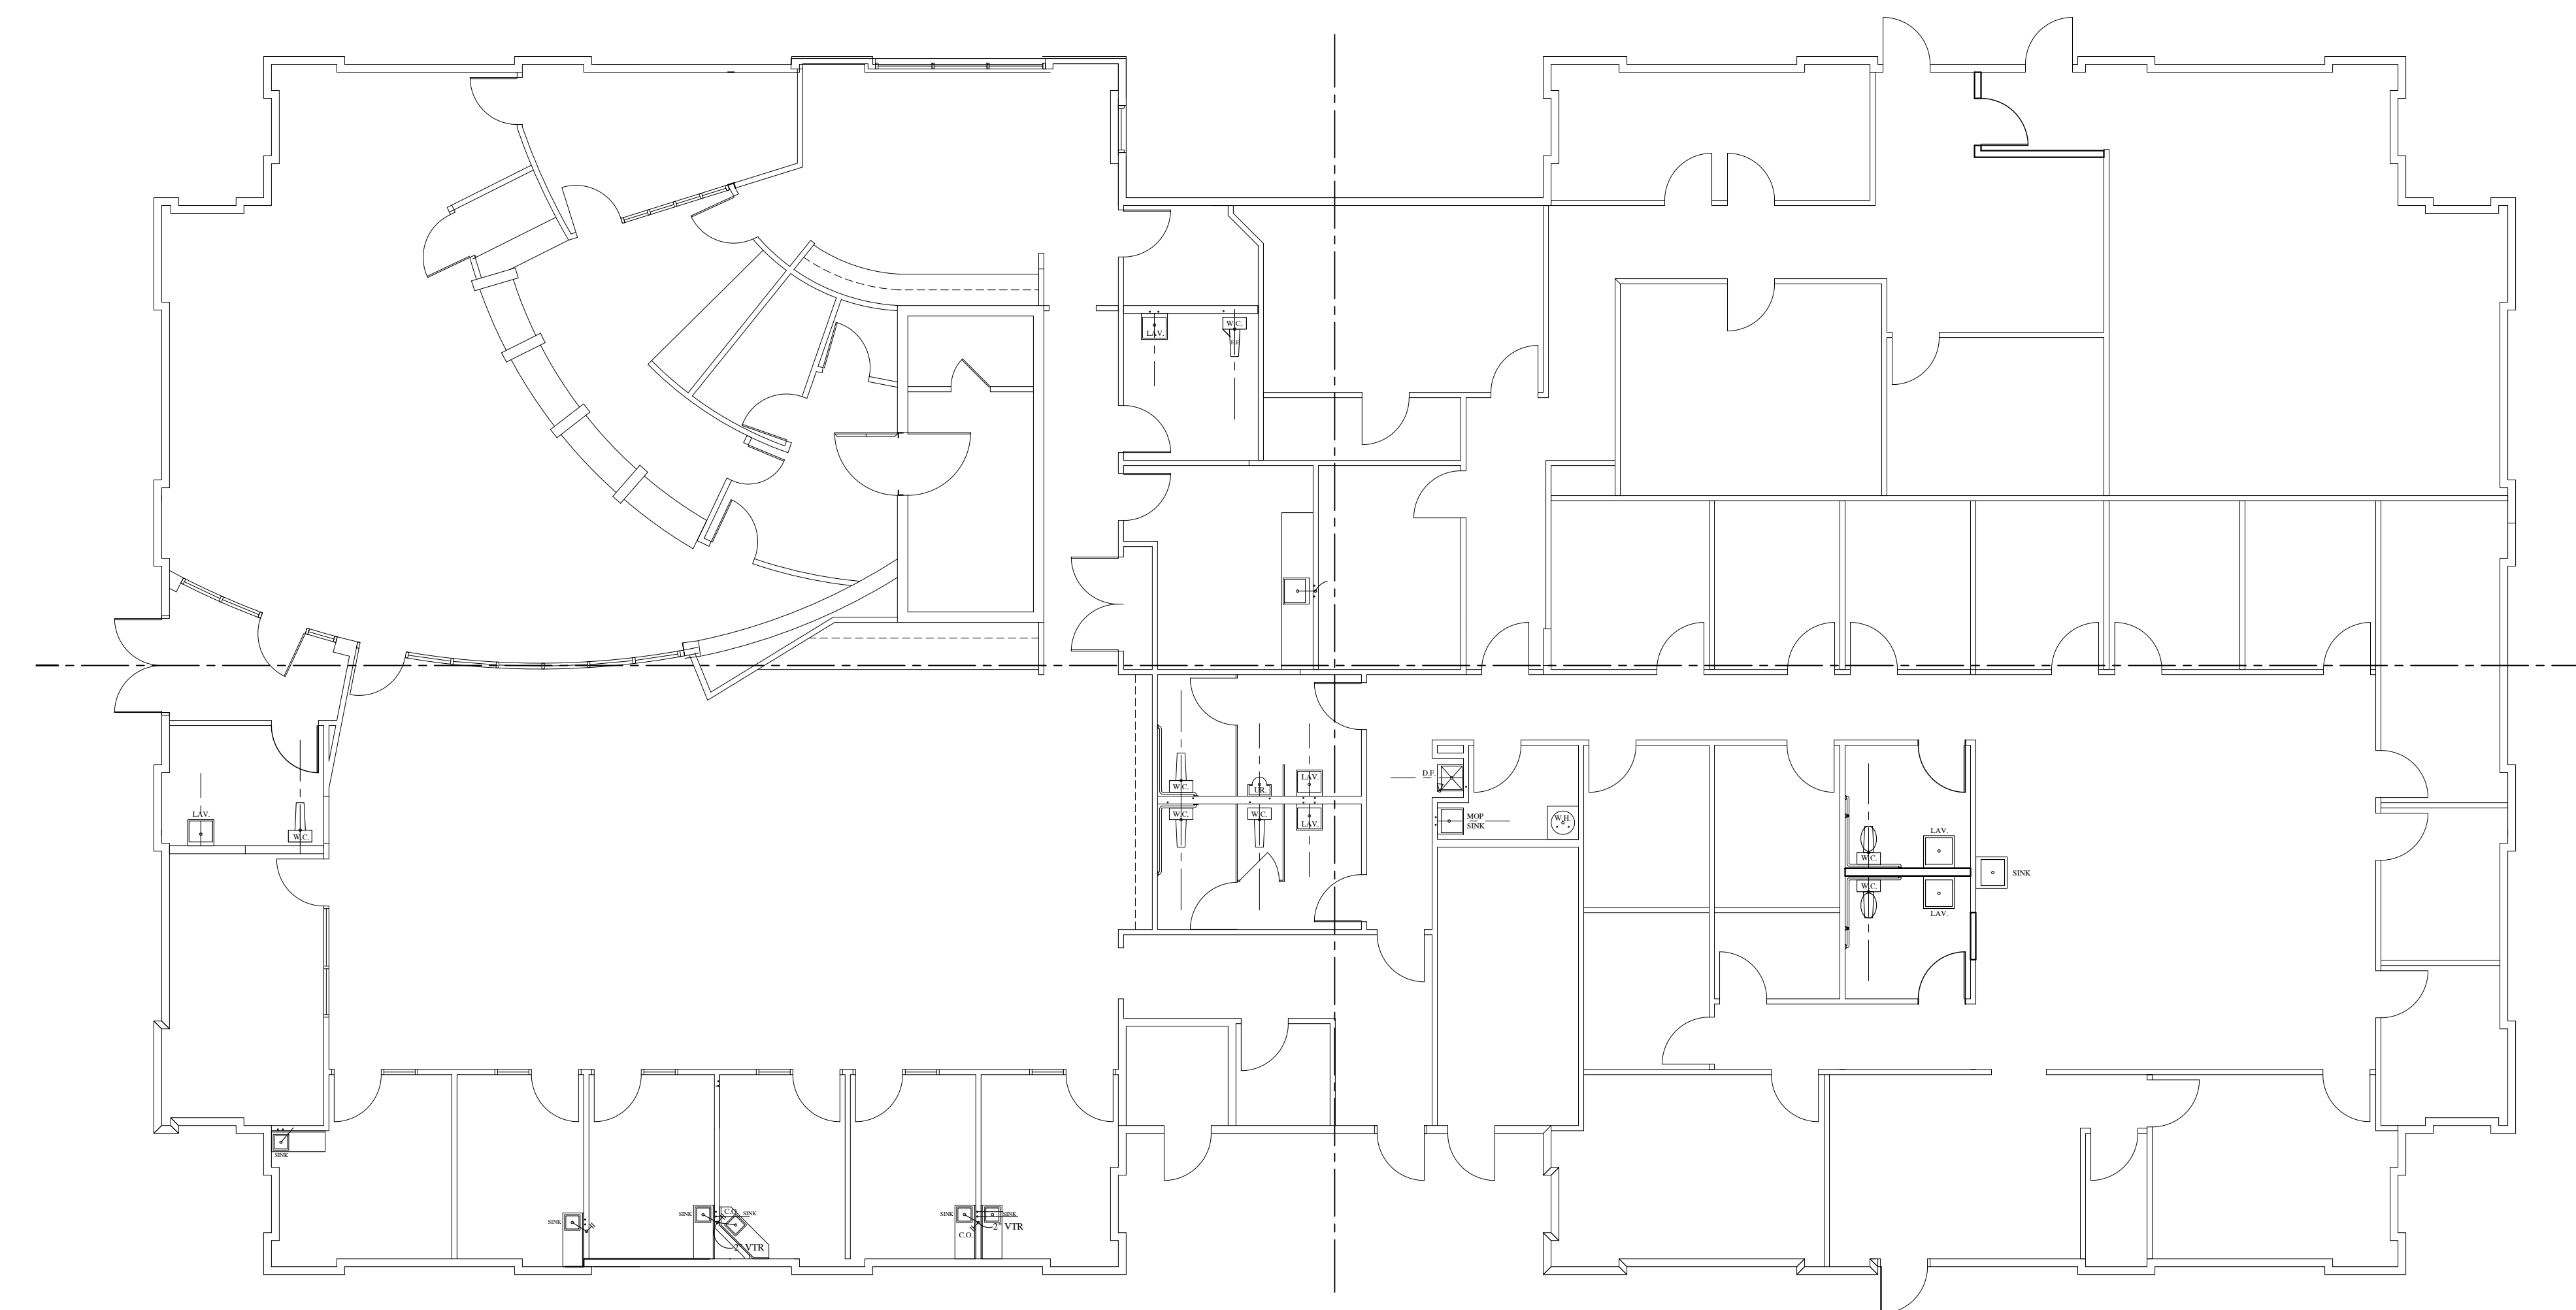

FLOOR PLAN
SCALE: 1/8" = 1' - 0"

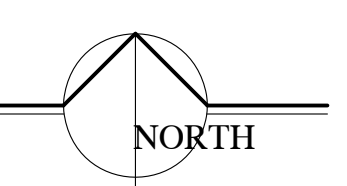

No.	DATE	REVISION

JERRY RAMSEY CONSTRUCTION
4595 KEVIN WAY
LAS VEGAS NV 89129
PH. 702.227.0266 FAX 702.227.3828
NV LICENSE #30551

STAMP

PROJECT FOR
Rapid Care Medical
Clinic
2610 S. JONES BLVD.
LAS VEGAS NV 89103

PROJECT NAME
New R/R & Offices

PROJECT ADDRESS
APN: 163-12-114-001

SHEET TITLE
PLUMBING PLANS

NOTES

PROJ No. 1 21-XXX

DATE 1-15-21

DRAWN BY:

CHECKED BY:

DWG. No

P1.0