



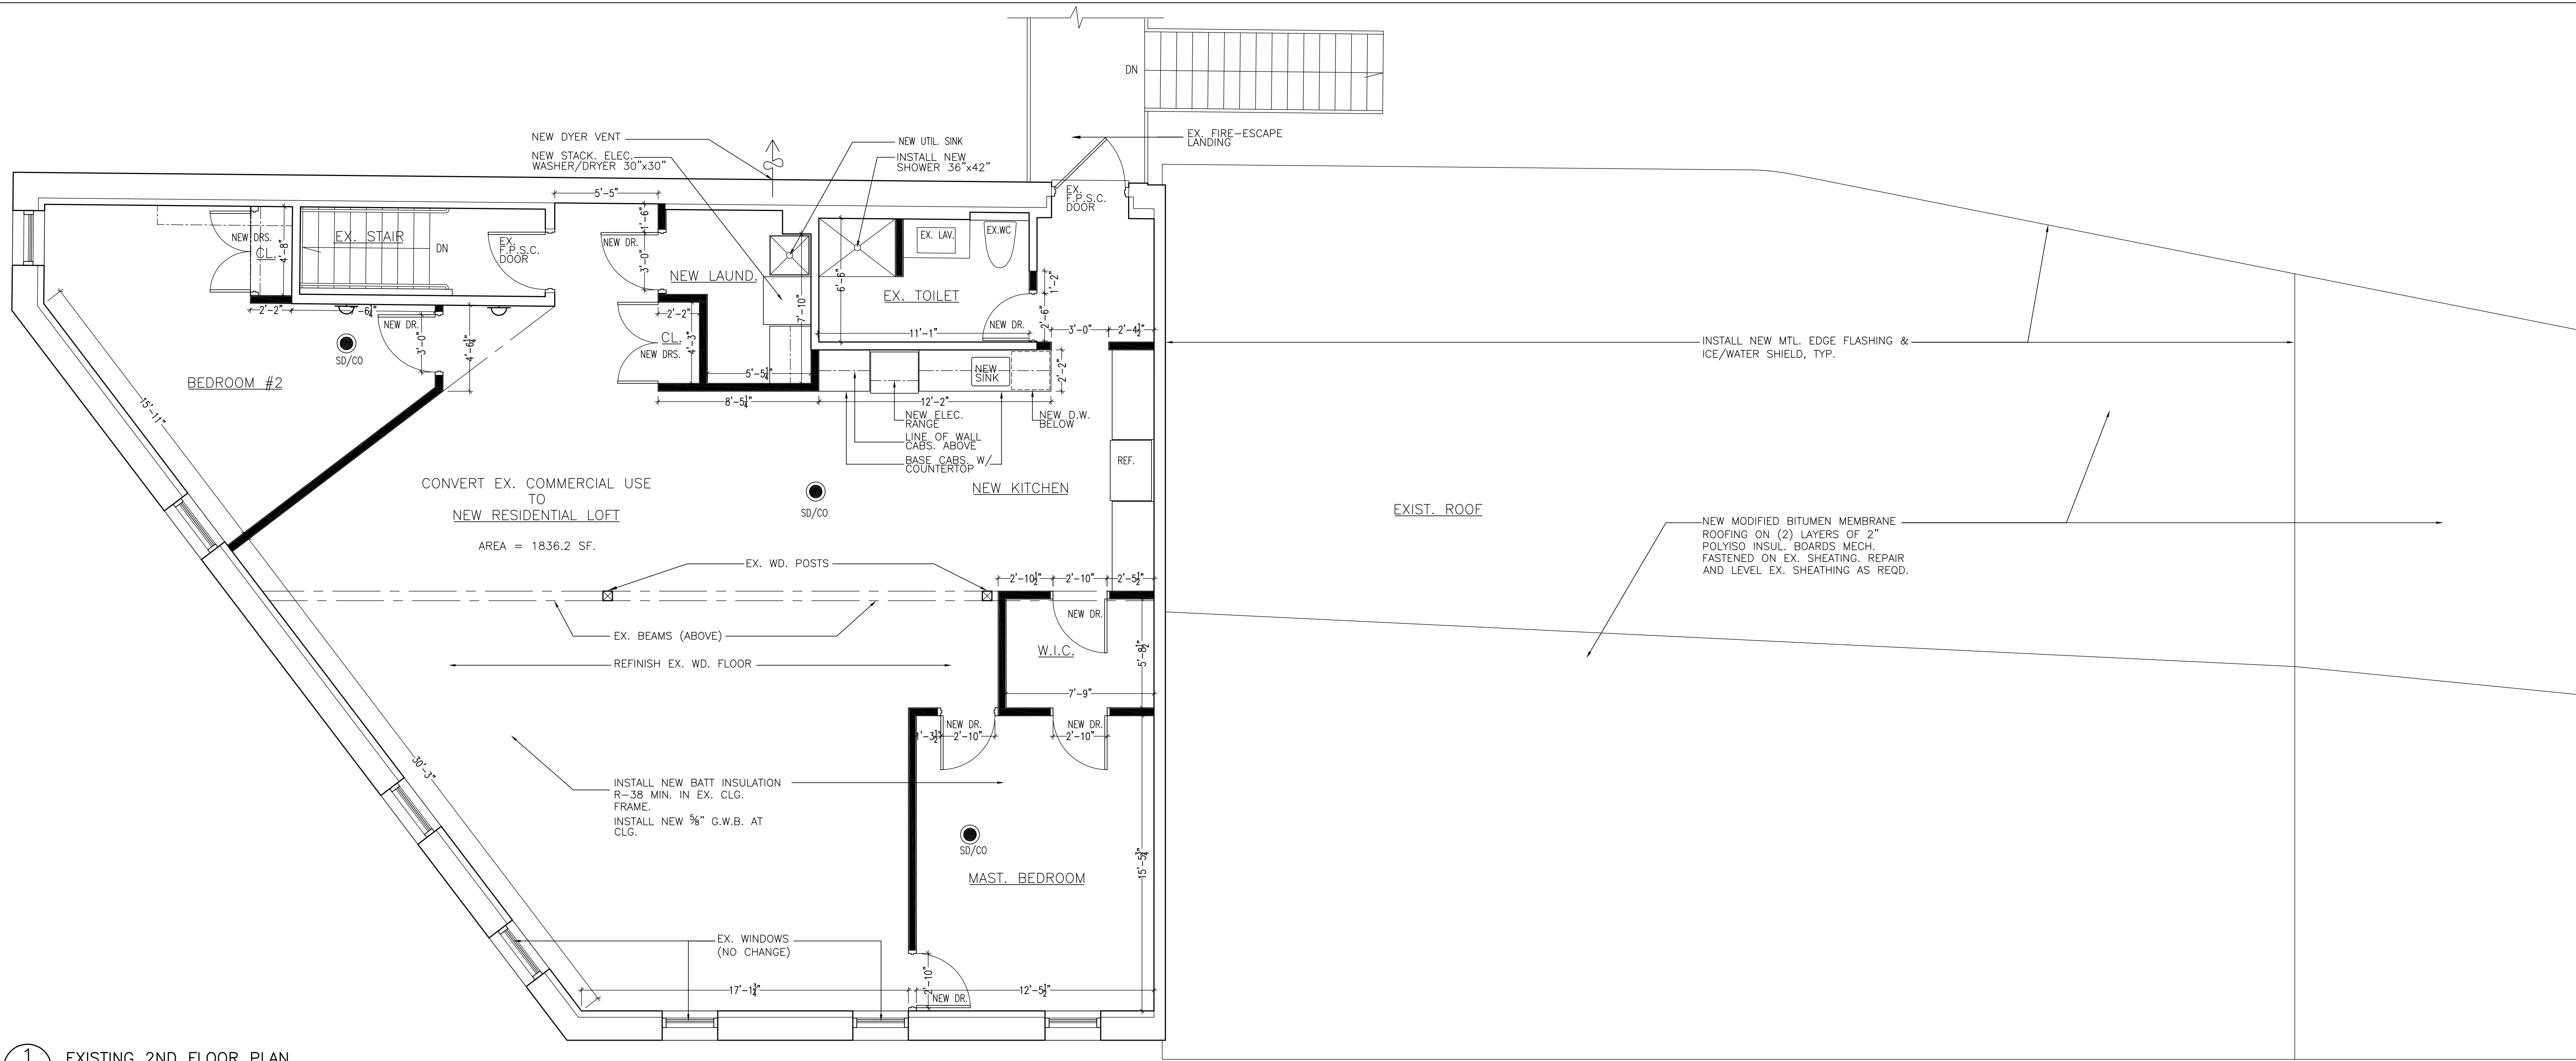


1 EXISTING 2ND FLOOR PLAN
SCALE: 1/4" = 1'-0"


LEGEND	
	EXISTING PARTITION OR WALL TO REMAIN (NO CHANGE).
	EXISTING ITEM TO BE REMOVED.
	NEW DRYWALL G.W.B. -- 3 1/2" MTL. STUDS @ 16" O.C., WITH ONE LAYER OF 5/8" GYPSUM BOARD EACH SIDE; BUILT FROM FLOOR SLAB TO UNDERSIDE OF CLG. ABOVE.
	DENOTES CONSTRUCTION ELEMENT OR FEATURE LOCATED ABOVE.
	EXISTING DOOR TO REMAIN.
	NEW DOOR AND HOLLOW METAL BUCK. (INCOMBUSTIBLE RATING - MINIMUM).
	PHOSPHORESCENT TYPE EXIT LIGHT AND SIGN WITH BATTERY BACKUP IN ACCORDANCE WITH SECTION [C26-606.1 - 4] 27-383-386 NYC ADMIN. BLDG. CODE, AND LOCAL LAW #16. DENOTES DIRECTIONAL ARROW WHEN APPLICABLE.
	NEW COMBINATION SMOKE AND C.O. DETECTOR

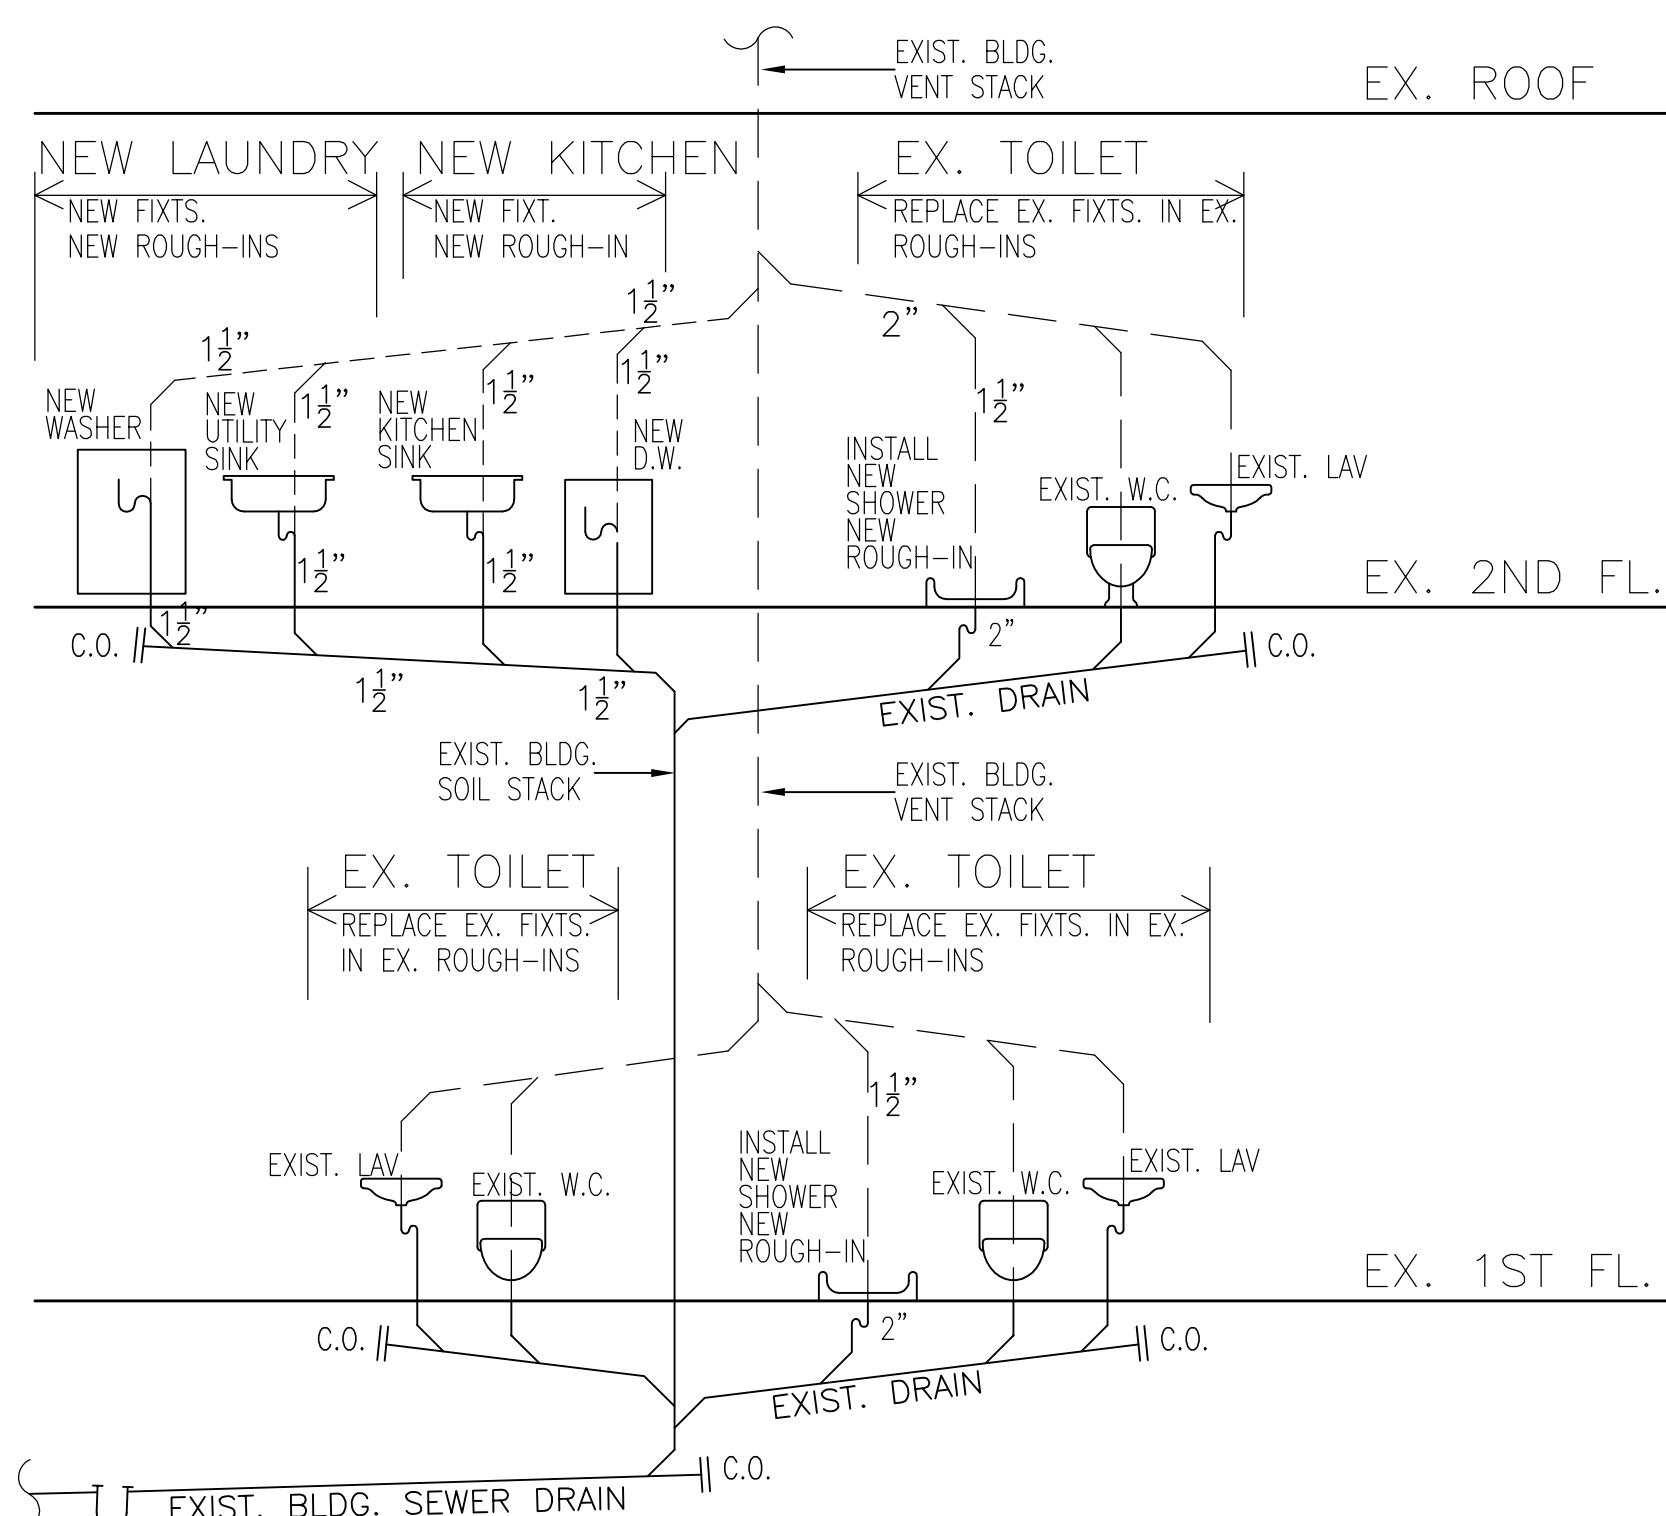

2 PLUMBING RISER DIAGRAM
N.T.S.

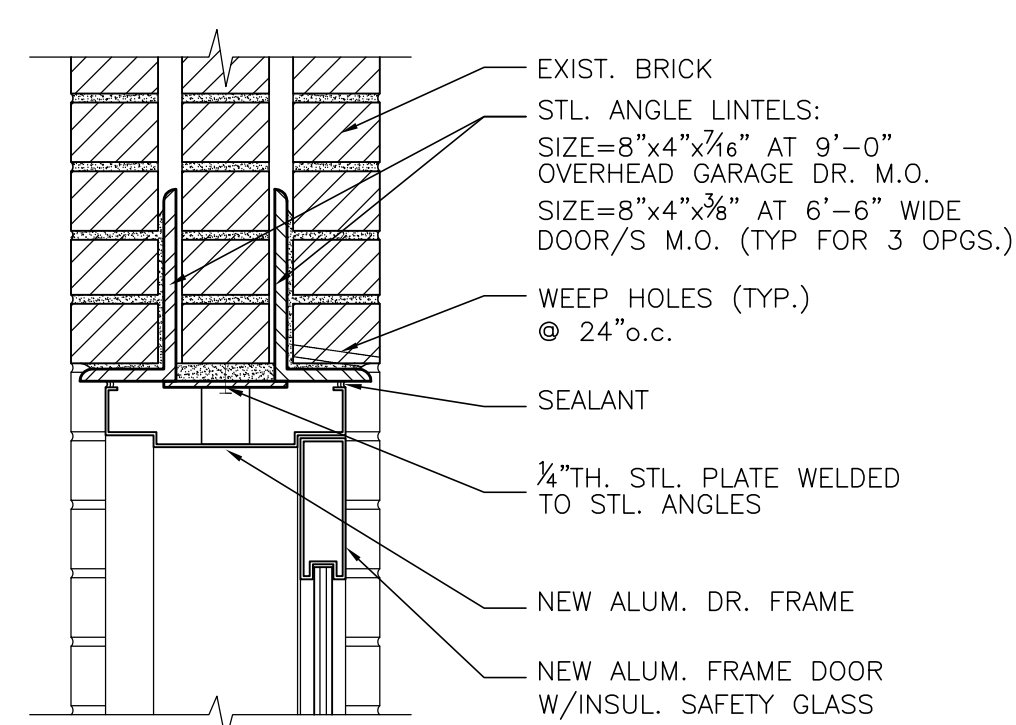


3 LINTEL DETAIL
SCALE: 1 1/2" = 1'-0"

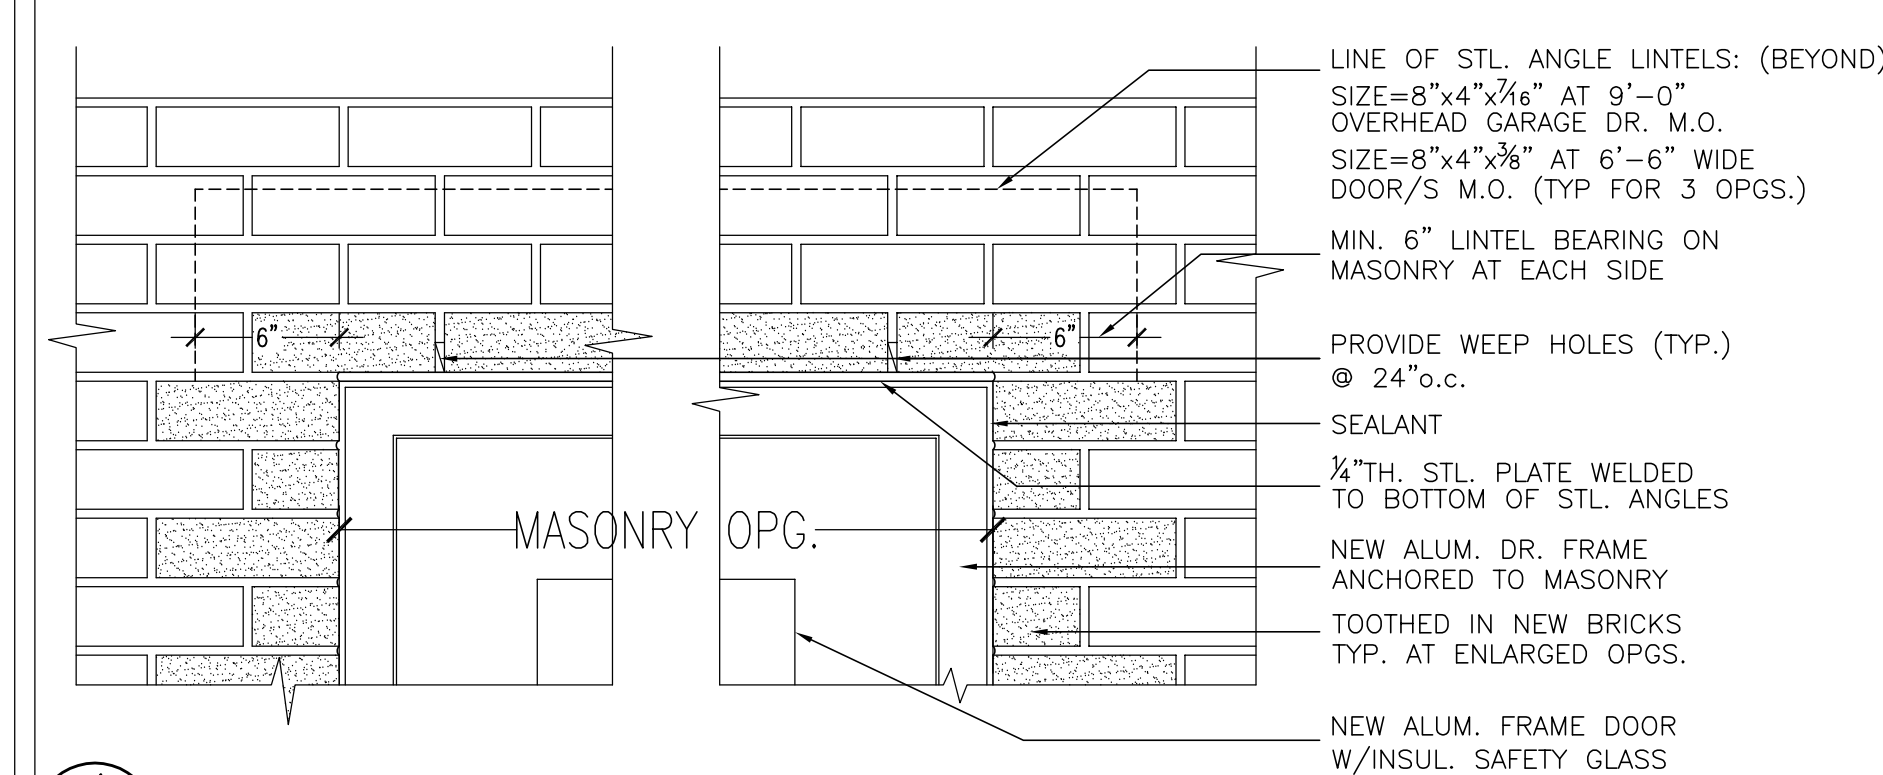

4 TYP. ELEVATION - LINTEL DETAIL
SCALE: 1 1/2" = 1'-0"

REVISIONS:
10-07-15 REVISED AS PER CLIENT REQUEST.
10-31-16 AS BUILT

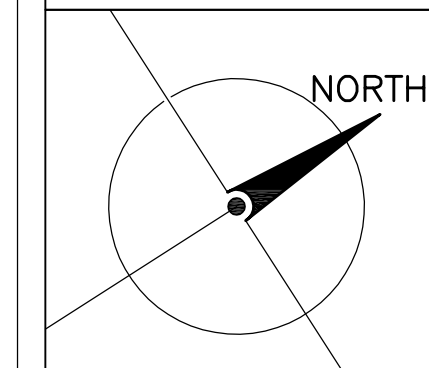

REZNY PHOTOGRAPHY STUDIO
76 PRINCE STREET
KINGSTON, N.Y.

SHASHANK V. KAMAT
ARCHITECT
12 BROWN DR.
ANDOVER, CT. 06232
(860) 742-0825 1611
(860) 742-6510 fax

PROJECT:
ALTERATION TO:
76 PRINCE STREET
KINGSTON, N.Y.

2ND FLOOR PLAN, LEGEND &
PLUMBING RISER DIAGRAM

DATE: 06-07-15
SCALE: AS NOTED
PROJ. NO. -

DWG. NO. **A-101**
SHEET NO. 2 of 2