



EXISTING RAMP




EXIST'G STAIR

EXIST'G ELEVATOR

SMOKE CURTAIN RECESSED MOUNTED IN CEILING AS MANUF. BY "SMOKE GUARD SYSTEM", CONNECTED TO FIRE ALARM SYSTEM. SEE ATTACHED SPEC. SHEET

FLOOR PLAN - BASEMENT
SCALE: 1/8" = 1'-0"

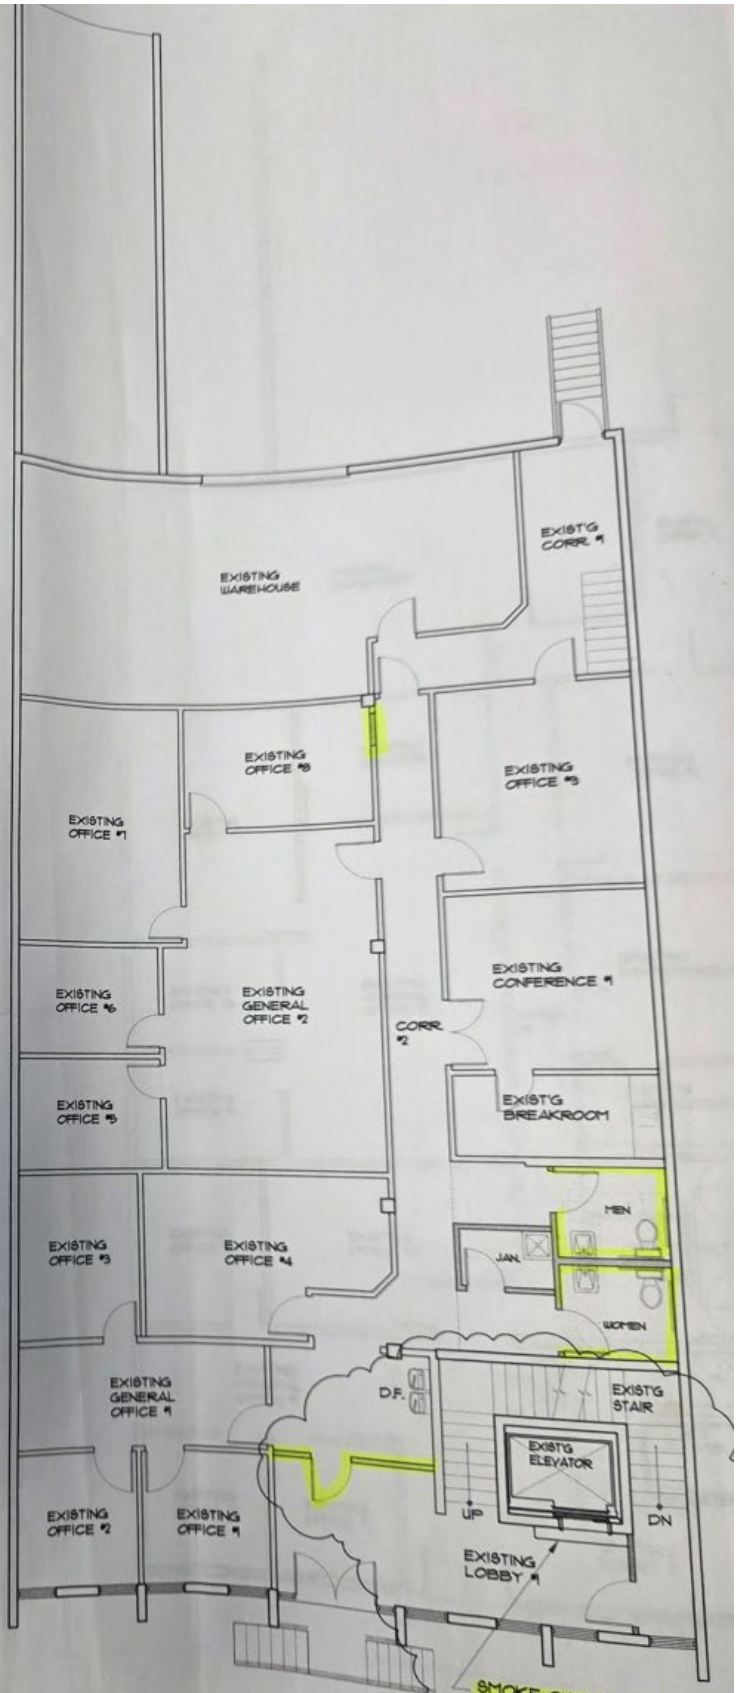

EXISTING WAREHOUSE

EXIST'G CORR. #1

EXISTING OFFICE #8

EXISTING OFFICE #9

EXISTING OFFICE #1

EXISTING OFFICE #6

EXISTING GENERAL OFFICE #2

EXISTING CONFERENCE #1

EXISTING OFFICE #5

CORR. #2

EXIST'G BREAKROOM

EXISTING OFFICE #3

EXISTING OFFICE #4

MEN

JAN.

WOMEN

EXISTING GENERAL OFFICE #1

D.F.

EXIST'G STAIR

EXIST'G ELEVATOR

EXISTING OFFICE #2

EXISTING OFFICE #1

UP

DN

EXISTING LOBBY #1

SMOKE CURTAIN RECESSED IN CEILING AS MANUF. BY "SMOKE GUARD SYSTEM", CONNECTED TO FIRE ALARM SYSTEM. SEE ATTACHED SPEC. SHEET



FLOOR PLAN - 1st FLOOR
SCALE: 1/8" = 1'-0"

