


2 TYP. CAB. SECTION SCALE NONE
3 TYP. SINK SECTION SCALE NONE

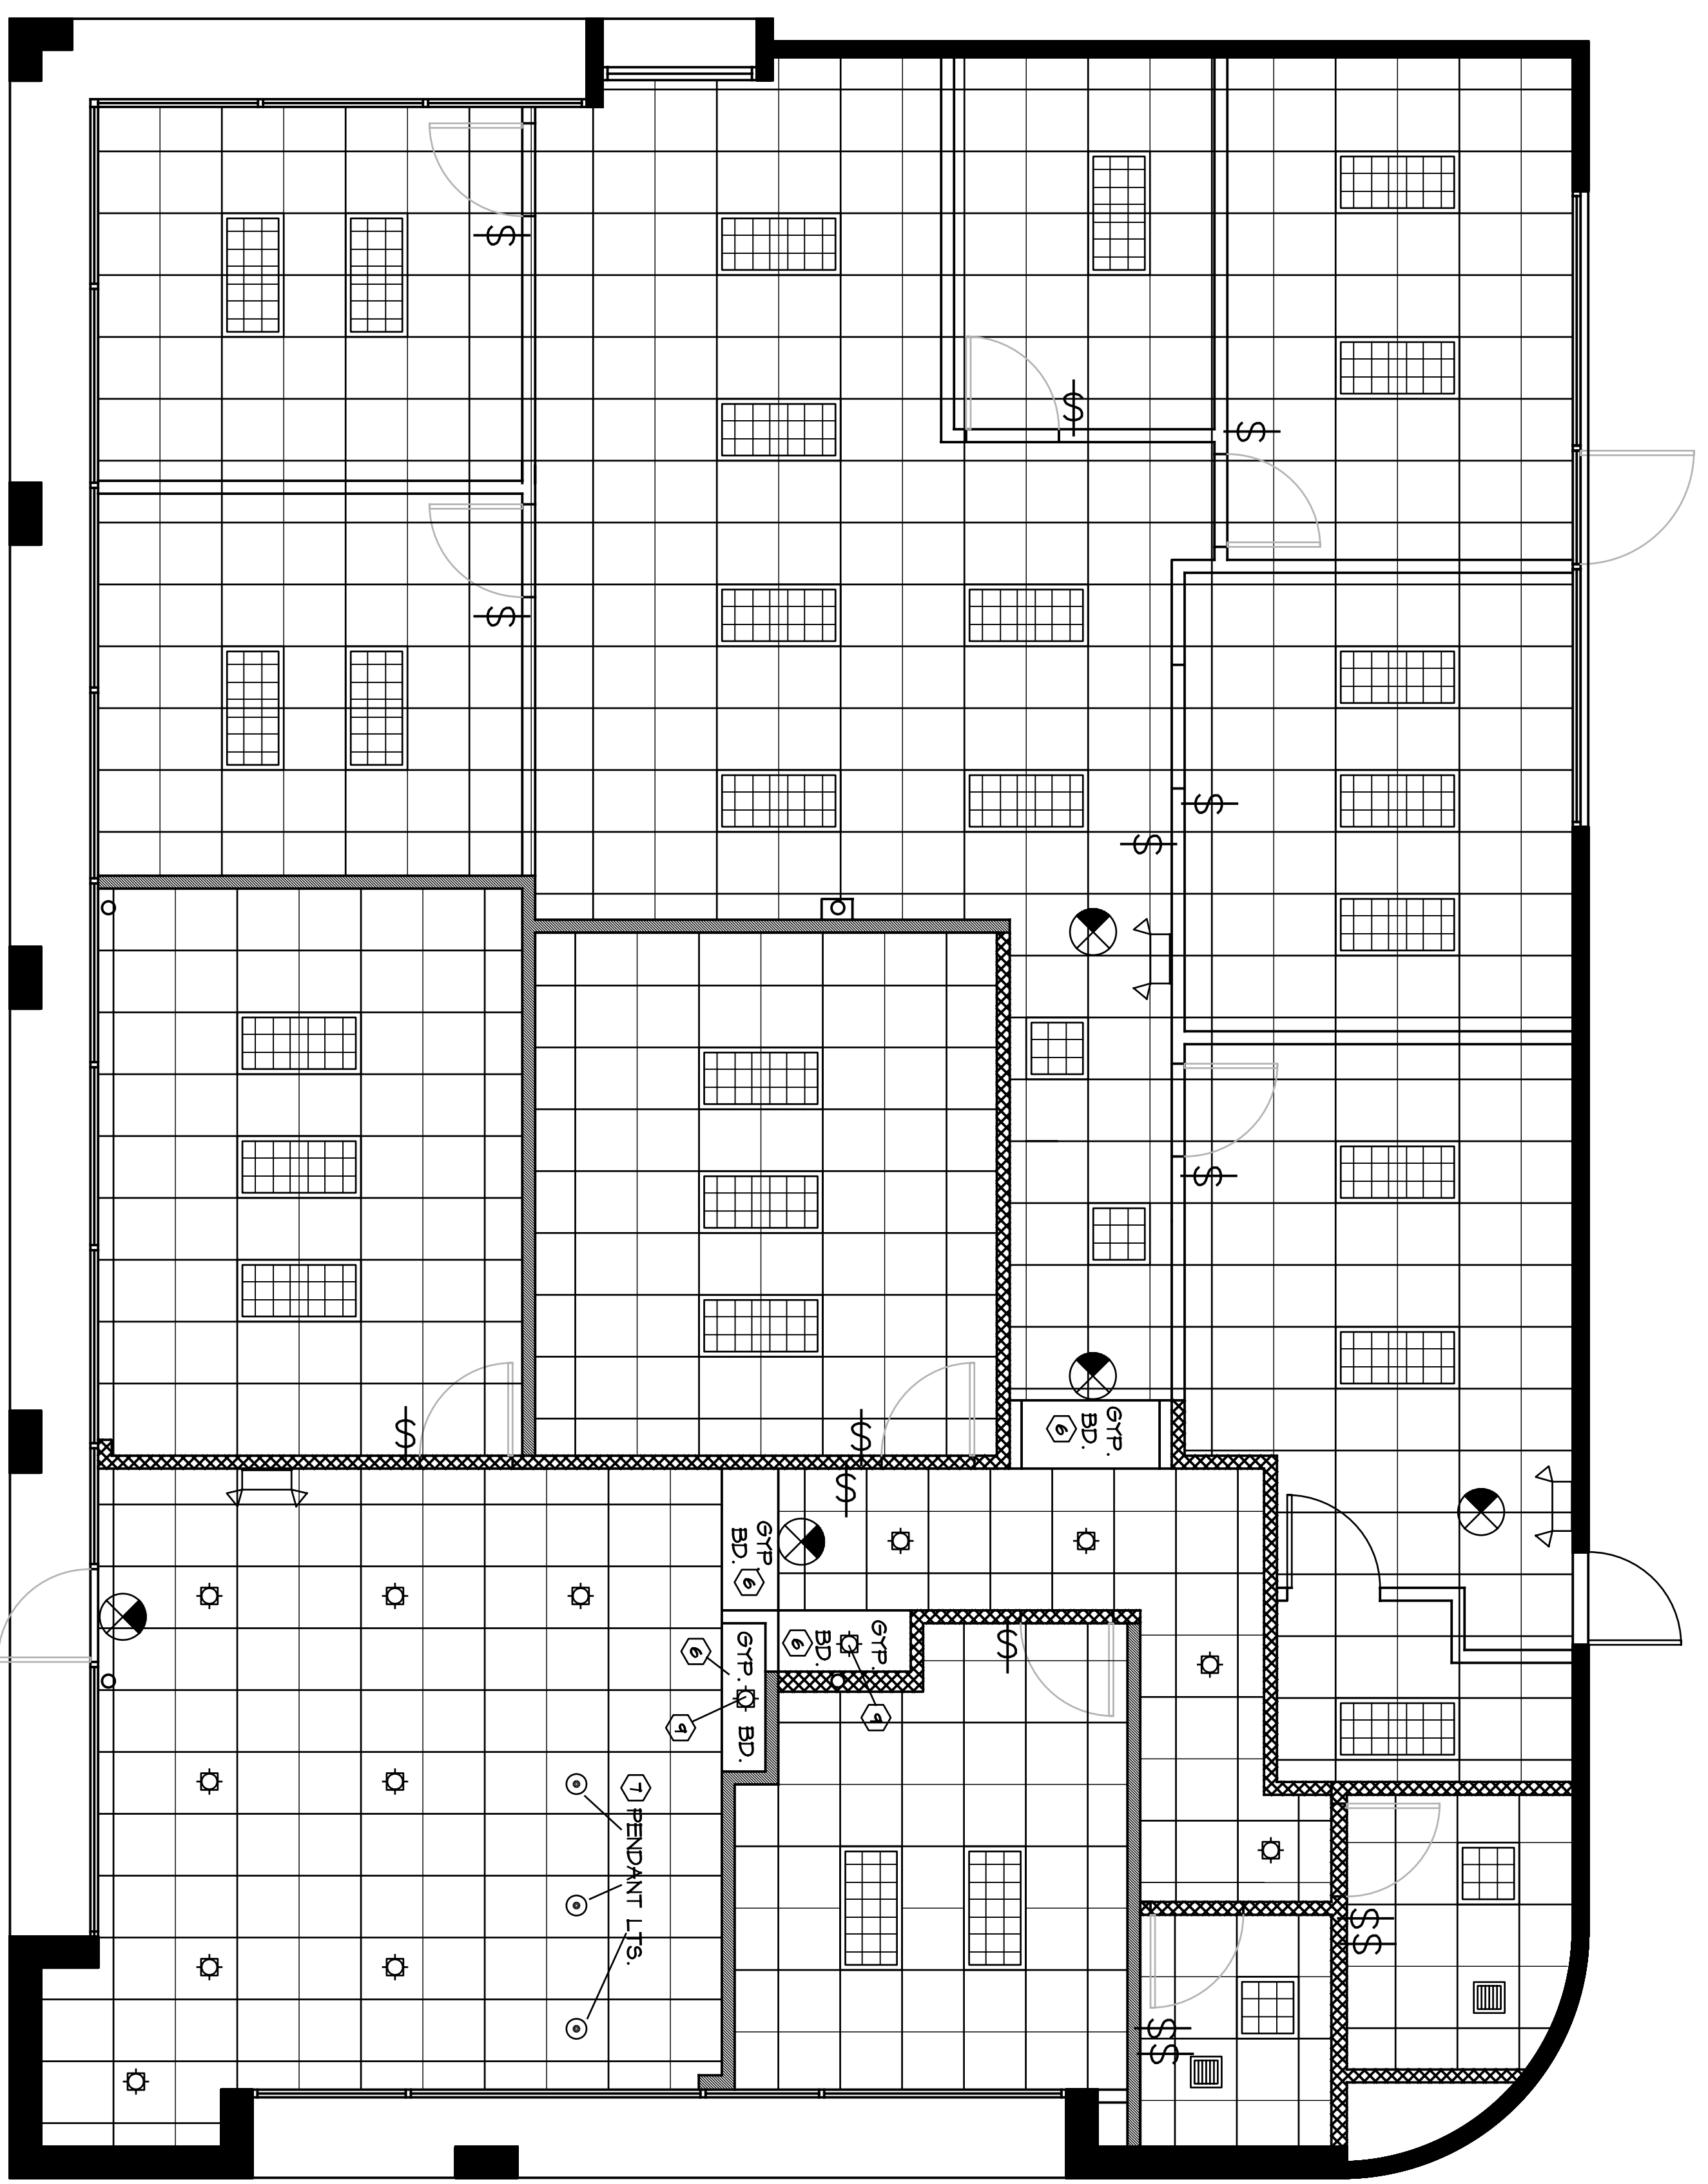

1 REFLECTED CEILING PLAN SCALE 1/4" = 1'-0"

SYMBOLS

SYMBOL	SPECIFICATIONS
[Grid symbol]	2'x4' PARABOLIC LIGHT FIXTURE
[Grid symbol]	2'x2' PARABOLIC LIGHT FIXTURE
[Circle with dot]	PENDANT LIGHT - BRICK LIGHTING RAINBOW DOWN
[Circle with dot]	DOWNLIGHT
[Circle with dot]	EXIT LIGHT
[Circle with dot]	LIGHT SWITCH
[Square with dot]	EXHAUST FAN
[Square with dot]	EMERGENCY LIGHT

- CEILING PLAN KEYED NOTES**
- NEW SUSPENDED CEILING AT 10'-0".
 - 2'x2' GRID LAYOUT. SOME ROOMS ARE INDIVIDUAL.
 - 2'x2' FIGURED TILE - ACT'L.
 - LIGHT FIXTURES AS SHOWN.
 - SWITCHES AS SHOWN, AT 54" AFF. UNO. SWITCH ENTIRE ROOM FROM SWITCH.
 - FURER DOWN TO 8'-0" A.F.F. PAINT PT-1.
 - CENTER PENDANT LIGHT IN 2'x2 TILE AT THIS LOCATION.
 - CENTER ALL DOWNLIGHTS IN THE CENTER OF THE 2'x2 TILE UNO.
 - THIS DOWNLIGHT IN A GYPSUM BOARD HANG DOWN. CENTER IN RECESS FROM SIDE TO SIDE AND FROM FRONT TO BACK.



COVER SHEET

DATE: 2/14/10
PROJECT NUMBER: IDTT-2-10
SHEET: A3

REVISIONS:

PETER R. WILSON
ARCHITECTURE
BOX 161223
AUSTIN, TEXAS 78716
PH: 512-633-3165
FX: 512-928-1978

INTERIOR REMODEL -
INDEPENDENCE TITLE-PLAZA BALCONES
ADDRESS
AUSTIN, TEXAS 78759