

1216 BIENVILLE RENOVATION

1216 BIENVILLE ST. NEW ORLEANS, LA 70112



3301 CHIPPEWA STREET
NEW ORLEANS, LA 70115
504.322.1220

[illegible]

SHEET INDEX			
Page Number	Sheet Number	Sheet Name	Sheet Issue Date
GENERAL			
1	T001	COVER SHEET & GENERAL PROJECT INFO	06/06/2025
2	T002	GENERAL NOTES, PROJECT KEYNOTES, & CODE REVIEW	06/06/2025
3	T003	LIFE SAFETY & EGRESS PLAN	09/26/2025
4	T004	ADA STANDARDS	09/26/2025
ARCHITECTURAL - SITE			
5	A100	SITE PLAN, ZONING, SURVEY, & ELEV. CERT.	06/06/2025
STRUCTURAL			
6	S1.0A	GENERAL STRUCTURAL NOTES	10/24/2025
7	S1.0B	GENERAL STRUCTURAL NOTES	10/24/2025
8	S2.0	FIRST FLOOR CEILING FRAMING PLAN	10/24/2025
9	S2.1	SECOND FLOOR / ROOF FRAMING PLAN	10/24/2025
10	S2.2	SECOND FLOOR CEILING AND ROOF FRAMING PLANS	10/24/2025
11	S2.3	FRAMING DETAILS	10/24/2025
12	S2.4	FRAMING SECTIONS AND DETAILS	10/24/2025
ARCHITECTURAL - DEMOLITION			
13	D101	EXISTING / DEMO FIRST FLOOR PLAN & NOTES	06/06/2025
14	D102	EXISTING / DEMO SECOND FLOOR PLAN & NOTES	06/06/2025
15	D103	EXISTING / DEMO SITE PLAN	09/26/2025
16	D201	EXISTING / DEMO EXTERIOR ELEVATIONS & NOTES	06/06/2025
17	D202	EXISTING / DEMO EXTERIOR ELEVATIONS & NOTES	06/06/2025
ARCHITECTURAL - PROPOSED			
18	A101	PROPOSED FIRST FLOOR PLAN & NOTES	06/06/2025
19	A102	PROPOSED SECOND FLOOR PLAN & NOTES	06/06/2025
20	A201	PROPOSED EXTERIOR ELEVATIONS & NOTES	06/06/2025
21	A202	PROPOSED EXTERIOR ELEVATIONS & NOTES	06/06/2025
22	A301	PROPOSED BUILDING SECTIONS & NOTES	06/06/2025
23	A501	CONSTRUCTION DETAILS	09/26/2025
24	A503	ROOF DETAILS TPO	12/15/23
25	A601	DOOR, WINDOW, & WALL SCHEDULE & NOTES	09/26/2025
ARCHITECTURAL - ID			
26	A800	ROOM MATERIAL/FINISH SCHEDULE & NOTES, INTERIOR DETAILS	09/26/2025
27	A802	INTERIOR FINISH PLANS & NOTES	09/26/2025
28	A803	INTERIOR ELEVATIONS & NOTES	09/26/2025
29	A804	INTERIOR ELEVATIONS & NOTES	07/28/2025
30	A805	INTERIOR ELEVATIONS & NOTES	07/28/2025
PLUMBING			
31	P001	PLUMBING SYMBOLS, NOTES, SCHEDULES ABBREVIATIONS	10/24/25
32	P101	FIRST FLOOR SEWER PLAN	10/24/25
33	P102	SECOND FLOOR SEWER PLAN	10/24/25
34	P201	FIRST FLOOR PLUMBING PLAN	10/24/25
35	P202	SECOND FLOOR PLUMBING PLAN	10/24/25
36	P300	PLUMBING DETAILS	10/24/25
MECHANICAL			
37	M001	MECHANICAL NOTES SYMBOLS & ABBREVIATIONS	10/14/25
38	M002	MECHANICAL SCHEDULES	10/14/25
39	M003	MECHANICAL SPECIFICATIONS	10/14/25
40	M101	FIRST FLOOR HVAC PLAN	10/14/25
41	M102	SECOND FLOOR HVAC PLAN	10/14/25
42	M300	MECHANICAL DETAILS	10/14/25
ELECTRICAL			
43	E000	SCHEDULES AND ABBREVIATIONS	10/14/25
44	E001	LUMINAIRE SCHEDULE	10/14/25
45	E002	GENERAL ELECTRICAL NOTES	10/14/25
46	E003	SPECIFICATIONS	10/14/25
47	E100	DEMO FIRST FLOOR	10/14/25
48	E101	DEMO SECOND FLOOR	10/14/25
49	E102	ELECTRICAL SITE	10/14/25
50	E200	LIGHTING FIRST FLOOR	10/14/25
51	E201	LIGHTING SECOND FLOOR	10/14/25
52	E300	POWER FIRST FLOOR	10/14/25
53	E301	POWER SECOND FLOOR	10/14/25
54	E700	POWER RISER DIAGRAM	10/14/25

SCOPE OF WORK		ZONING INFORMATION	
RENOVATION & ADDITION OF EXISTING BUILDING AND CONVERSION TO A SINGLE APARTMENT ABOVE A 1ST FLOOR RESTAURANT.		MUNICIPAL DISTRICT: C: Freddie King II SQUARE / BLOCK: 124 LOT: 5-D	PARISH: ORLEANS ZONING DISTRICT: HU-MU SITE AREA: 2,048 SQ.FT.
SQUARE FOOTAGES			
EXISTING		PROPOSED	
FIRST FLOOR:	2,020 SQ.FT.	FIRST FLOOR:	2,020 SQ.FT.
SECOND FLOOR:	1,180 SQ.FT.	SECOND FLOOR:	1,271 SQ.FT.
GALLERY:	849 SQ.FT.	GALLERY:	849 SQ.FT.
HVAC PLATFORM:	197 SQ.FT.	HVAC PLATFORM:	97 SQ.FT.
TOTAL UNDER BEAM:	4,246 SQ.FT.	TOTAL UNDER BEAM:	4,237 SQ.FT.


14 OCT 2025	CD-99%
01 AUG 2025	DD-1
06 JUNE 2025	HDLC
28 MAY 2025	EC-1

Project: #2025-06

1216 BIENVILLE RENOVATION


ADDRESS:
1216 BIENVILLE ST. NEW ORLEANS, LA
70112

COVER SHEET & GENERAL PROJECT INFO

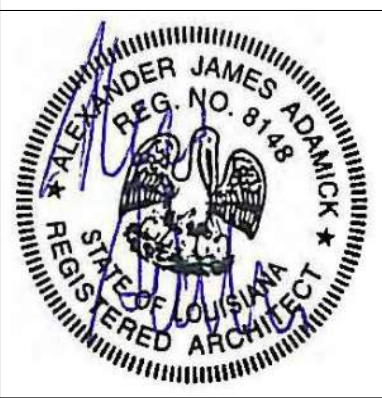



DATE: 10/28/2025 9:36:37 AM	
PROJECT NO.:	2025-06
DRAWING BY:	MMV
CHECKED BY:	AJA
SHEET NO.:	
T001	
CAD FILE NO: 2025-06\PDF OUT\CD	1 / 54

 SHEET LEGEND: ARCHITECTURAL

 SECTION REFERENCE	 INTERIOR ELEVATION REFERENCE
---	--

Room name 101 Room TAG, RE. SCHED. CLG: Ceiling Height Room name 101 Room FINISH TAG, RE. SCHED. Coiling Material Wall Material Floor Material	 WALL TAG. RE: SCHEDULES  WINDOW TAG. RE: SCHEDULES  DOOR TAG. RE: SCHEDULES  REVISION NUMBER XX-# SELECTION TAG. RE. SCHED. WOOD THRESHOLD
---	---

ABBREVIATIONS			
A/C	AIR CONDITIONING	HVAC	HEATING, VENTILATION, & A/C
A.F.F.	ABOVE FINISHED FLOOR	H.W.	HOT WATER HEATER
A.F.G.	ABOVE FINISHED GRADE	I.A.W.	IN ACCORDANCE WITH
ALT.	ALTERNATE	INSUL.	INSULATION
BDB	BEADED-BOARD	INT.	INTERIOR
BLDG.	BUILDING	MFR	MANUFACTURER
CL	CENTERLINE	MAX.	MAXIMUM
CLG	CEILING	MECH.	MECHANICAL
CLR	CLEARANCE	MIN.	MINIMUM
CMU	CONCRETE MASONRY UNIT	N.I.C.	NOT IN CONTRACT
CONC.	CONCRETE	N.T.S.	NOT TO SCALE
CONT.	CONTINUOUS	O.C.	ON CENTER
C.J.	CONTROL JOINT	PLUMB.	PLUMBING
COORD.	COORDINATE	PT	PAINT
DECOR.	DECORATIVE	PLY.	PLYWOOD
DTL	DETAIL	PL	PROPERTY LINE
DIAM.	DIAMETER	PTL	PRESSURE TREATED WOOD
DIM.	DIMENSION	PRIM.	PRIMARY
DN	DOWN	P.V.	PHOTOVOLTAIC
D.S.	DOWNSPOUT	RE.	REFERENCE
ELEC.	ELECTRICAL	REQ.	REQUIRED
ELEV.	ELEVATION	R.D.	ROOF DRAIN
EQ	EQUAL	RM	ROOM
EQUIP.	EQUIPMENT	SCHED.	SCHEDULE
E.J.	EXPANSION JOINT	SECT.	SECTION
EXT.	EXTERIOR	SIM.	SIMILAR
E.T.R.	EXISTING TO REMAIN	SHGT.	SHEATHING
F.B.O.	FURNISHED BY OWNER	SPEC.	SPECIFIED
F.D.	FLOOR DRAIN	STRUC.	STRUCTURAL
FLASH.	FLASHING	TEM.	TEMPERED
FLR	FLOOR	THK	THICK
FIN.	FINISH	T&G	TONGUE & GROOVE
F.F.L.	FINISHED FLOOR LEVEL	TYP.	TYPICAL
GC	GENERAL CONTRACTOR	VERT.	VERTICAL
GYP.	GYPSPUM BOARD	V.I.F.	VERIFY IN FIELD
HT.	HEIGHT	W/	WITH
HOR.	HORIZONTAL	WDW	WINDOW
HR	HOUR	WC	WATER CLOSET

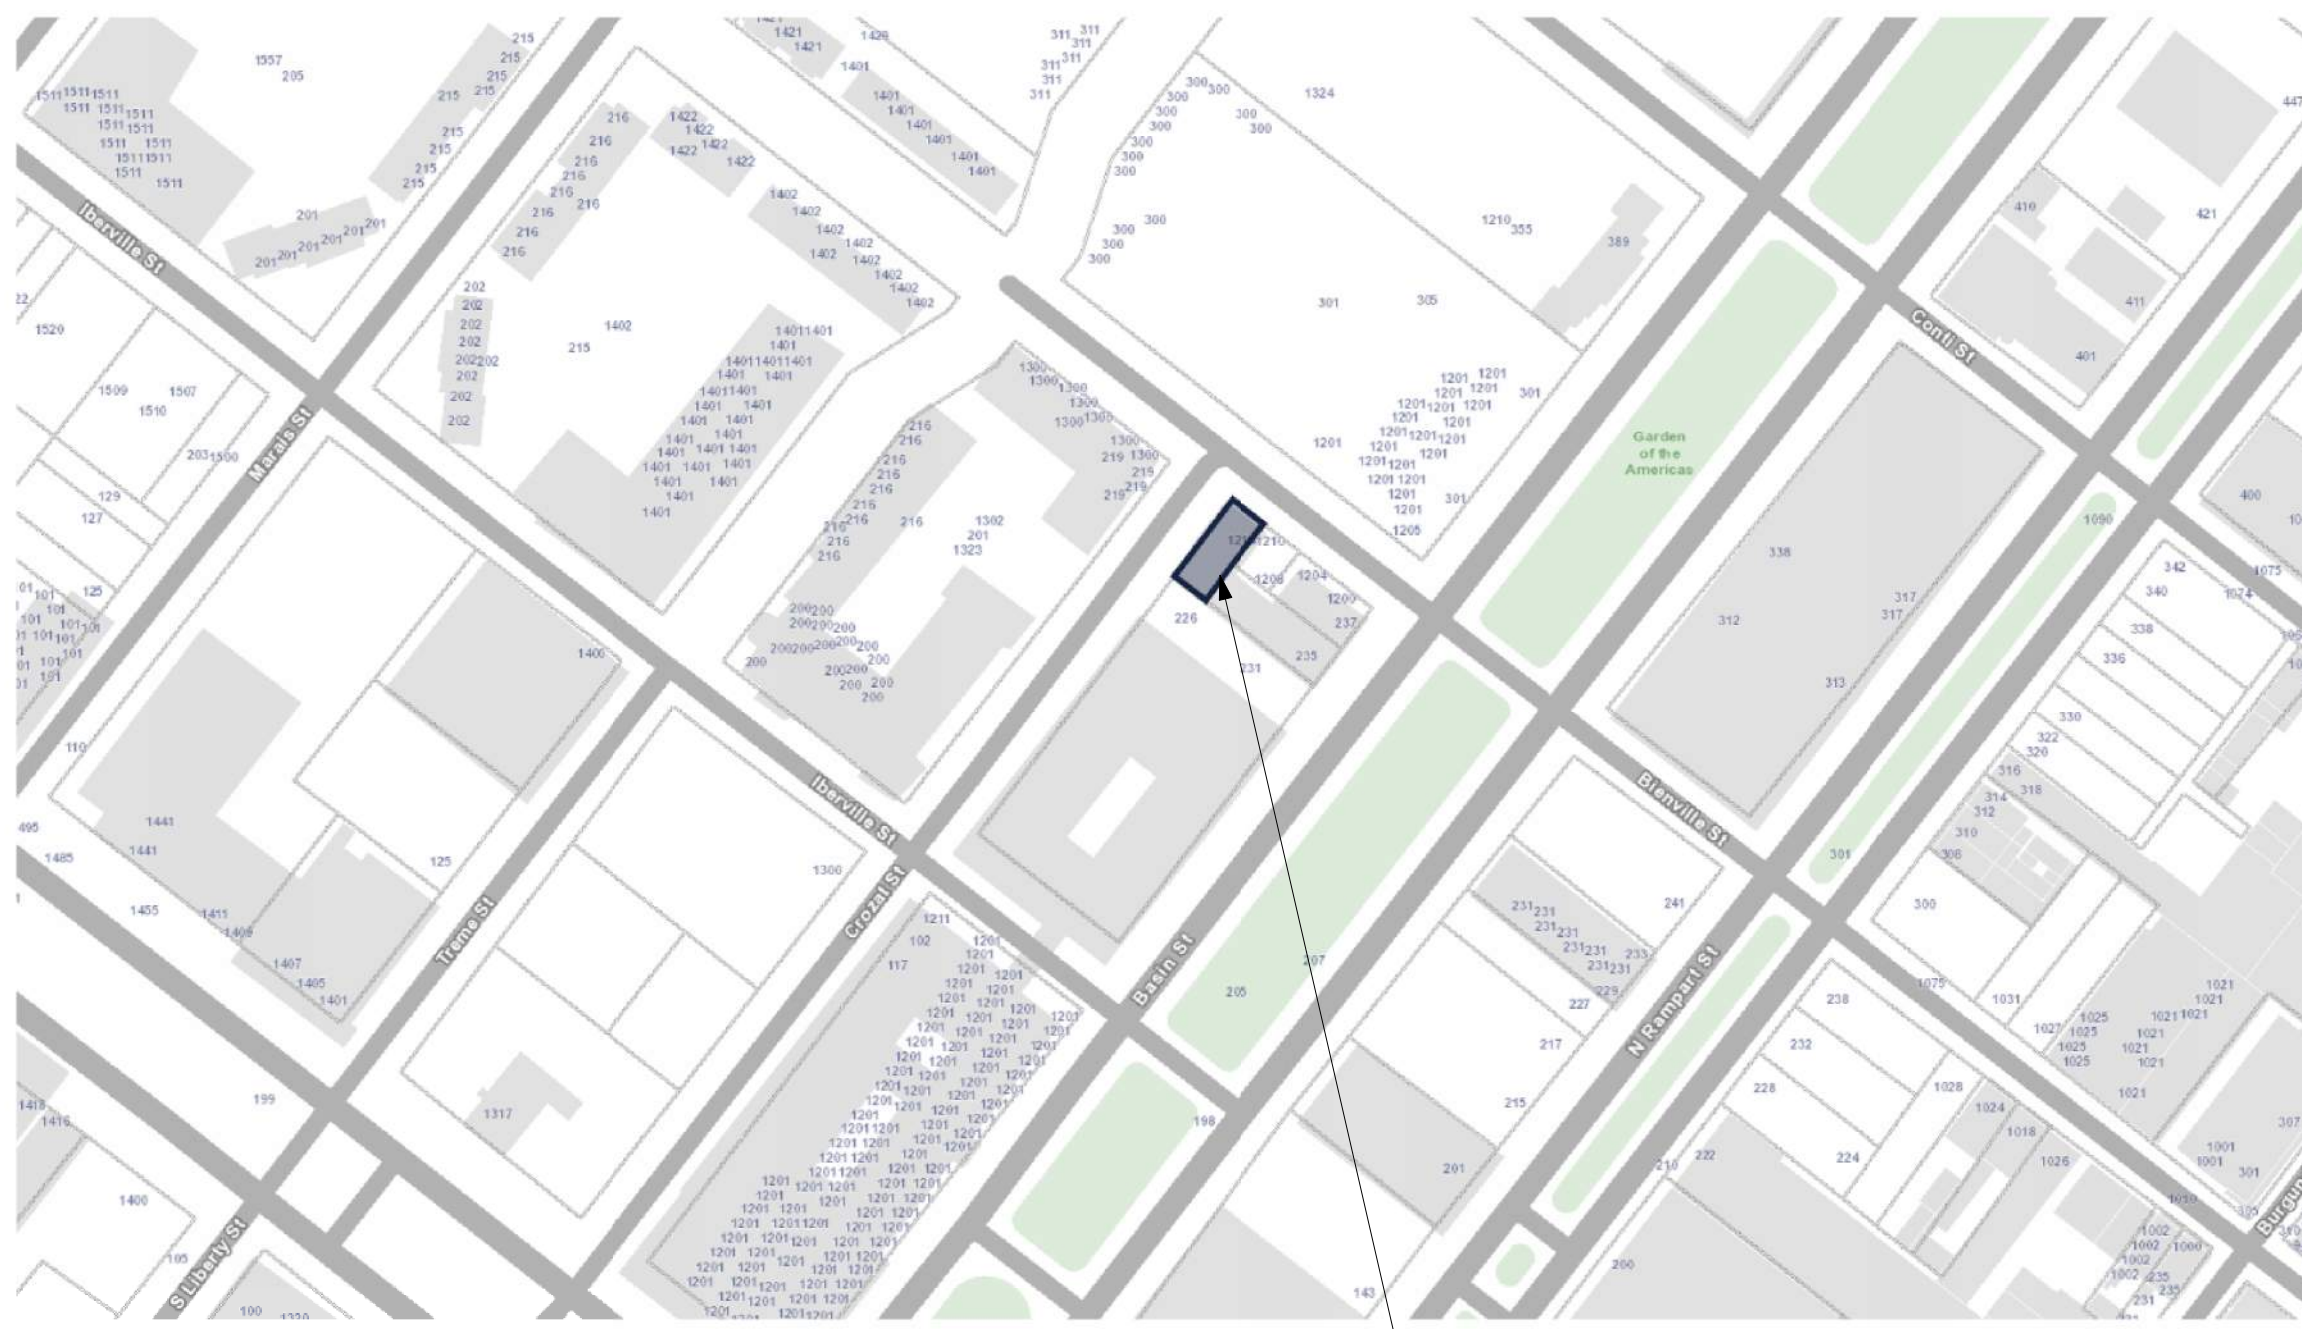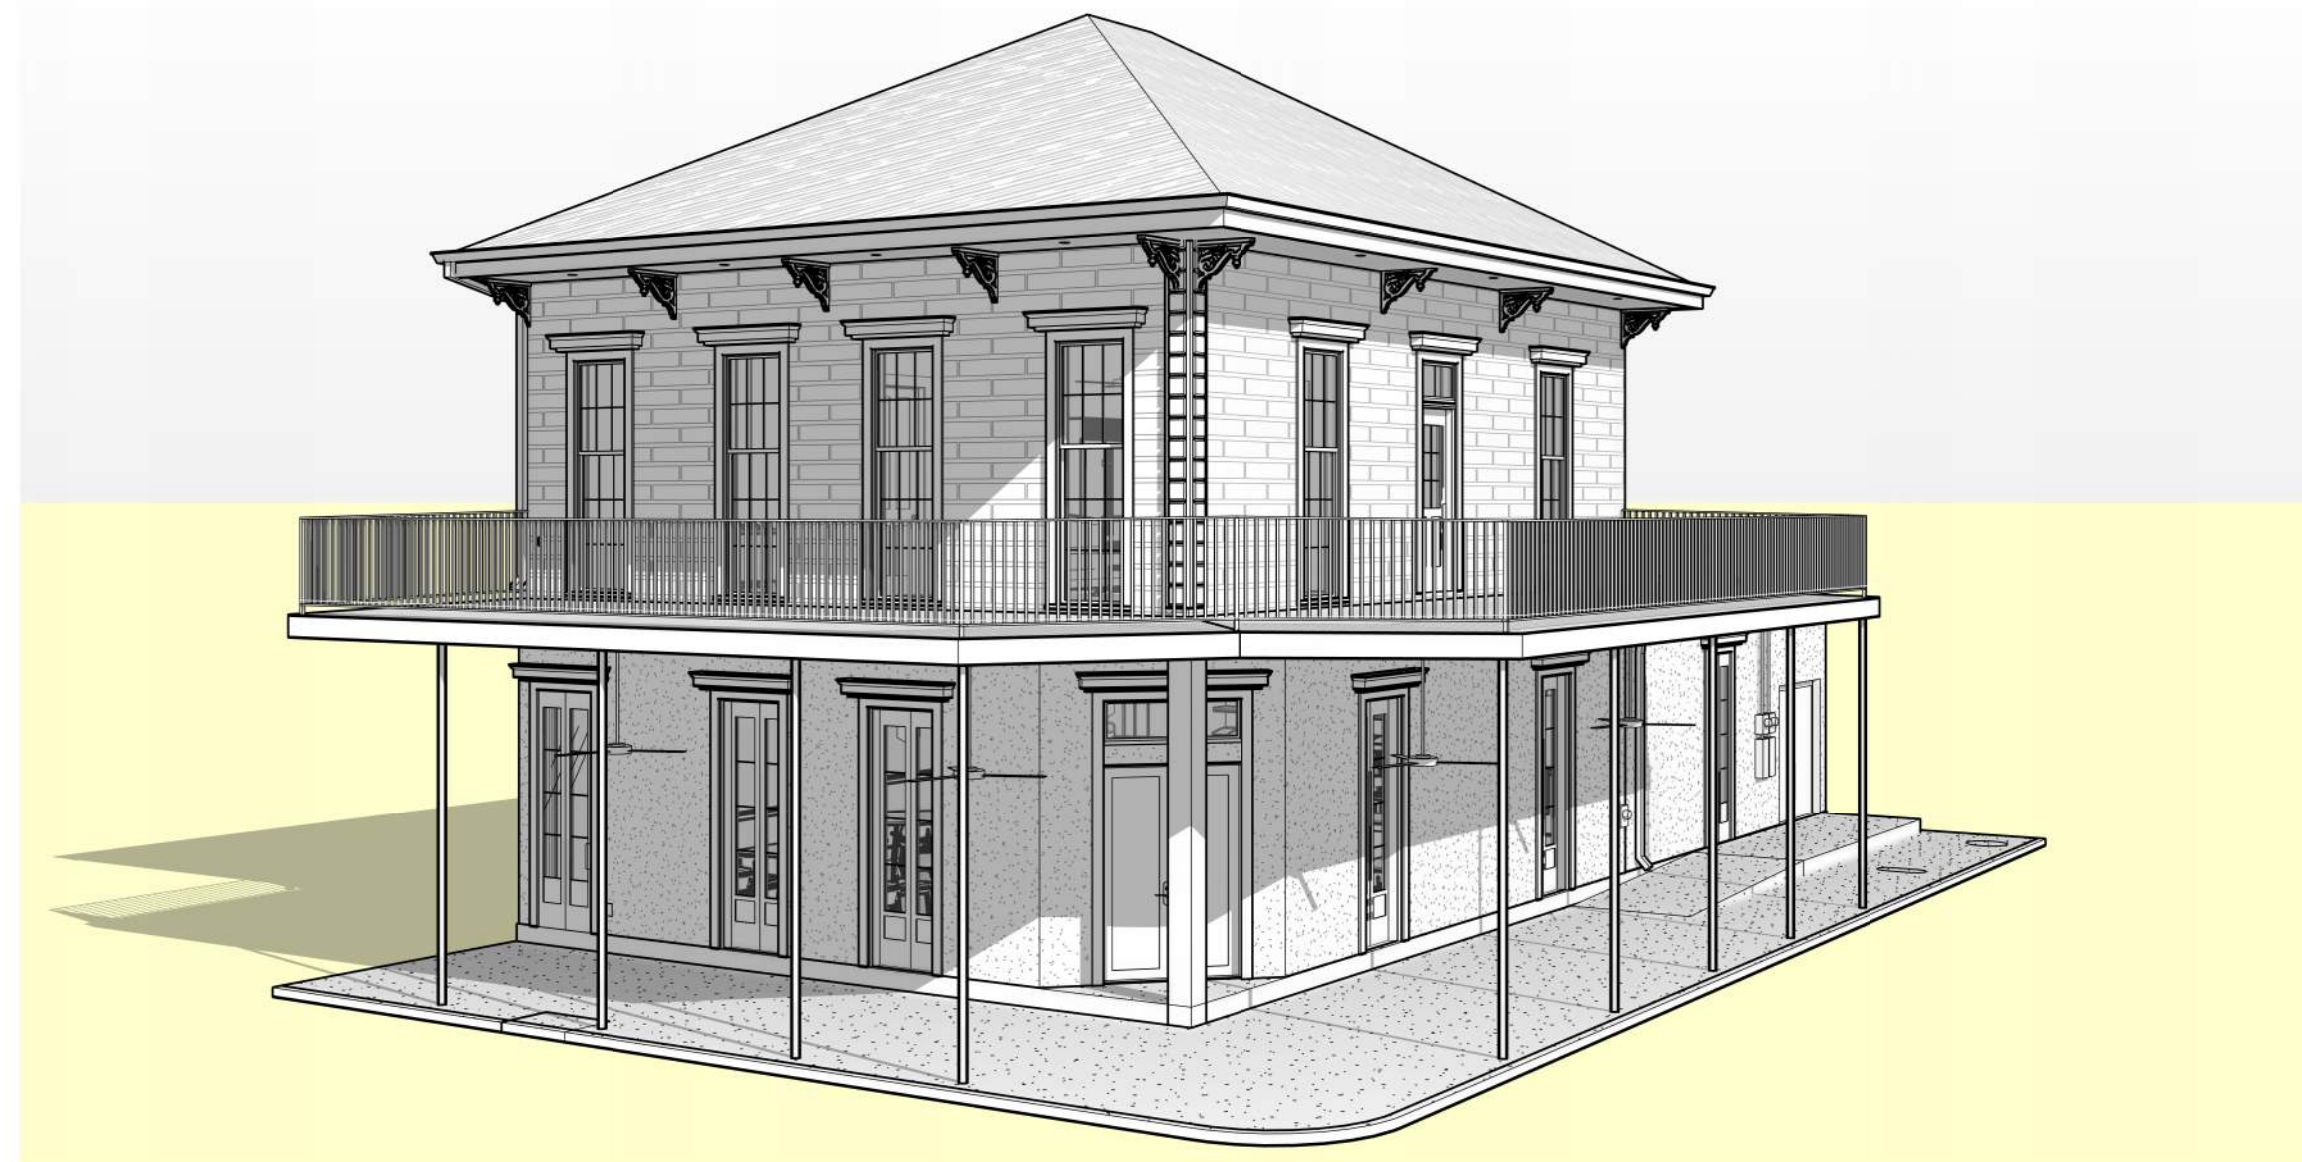

KEY PLAN

- HATCH INDICATES
PROJECT LOCATION

SCALE: N.T.S.

ARCHITECT:	STRUCT. ENGINEER	MECH. ENGINEER	ELECT. ENGINEER	CONTRACTOR	OWNER:
ADAMICK ARCHITECTURE 3301 Chippewa Street New Orleans, LA 70115 504.322.1220 Contact: Alec Adamick E-mail: alec@adamickarchitecture.com	AXIS ENGINEERING 3500 N. Causeway Blvd. Suite 650 Metairie, LA, 70002 504.380.0800 Contact: James Heaslip E-mail: james@axisengr.com	Herzog Engineering 4200 Cleary Ave. Metairie, LA, 70002 504-481-8739 Contact: Michael Herzog E-mail: michael@herzog-eng.com	Electrical Design Solutions 13430 N. Leah St Suite B Gonzales, La, 70737 844 337 1990 Contact: Raul Enrique Valdes E-mail: raul@ewithd.com	T.B.D. 337.849.7158	PERFECT PEAK PROPERTIES, LLC. 406 TERRY PARKWAY TERRYTOWN, LA 70056 Contact: TARK MOUSA E-mail: tarkmousa@yahoo.com

