



BUILDING CODES: All work shall comply with 2015 International Building Code, Village of Schaumburg Title 15 Chapter 153 Building Code, 2015 International Plumbing Code, State of Illinois 2014 Plumbing Code, of Schaumburg Title 15 Chapter 156 Plumbing Code, 2014 National Electric Code, Village of Schaumburg Title 15 Chapter 152 Electrical Code, 2015 International Mechanical Code, 2015 International Fuel Gas Code, current adopted State of Illinois Energy Conservation Code, 2015 International Existing Building Code, 2015 International Fire Code, Village of Schaumburg Chapter 157 Fire Code.

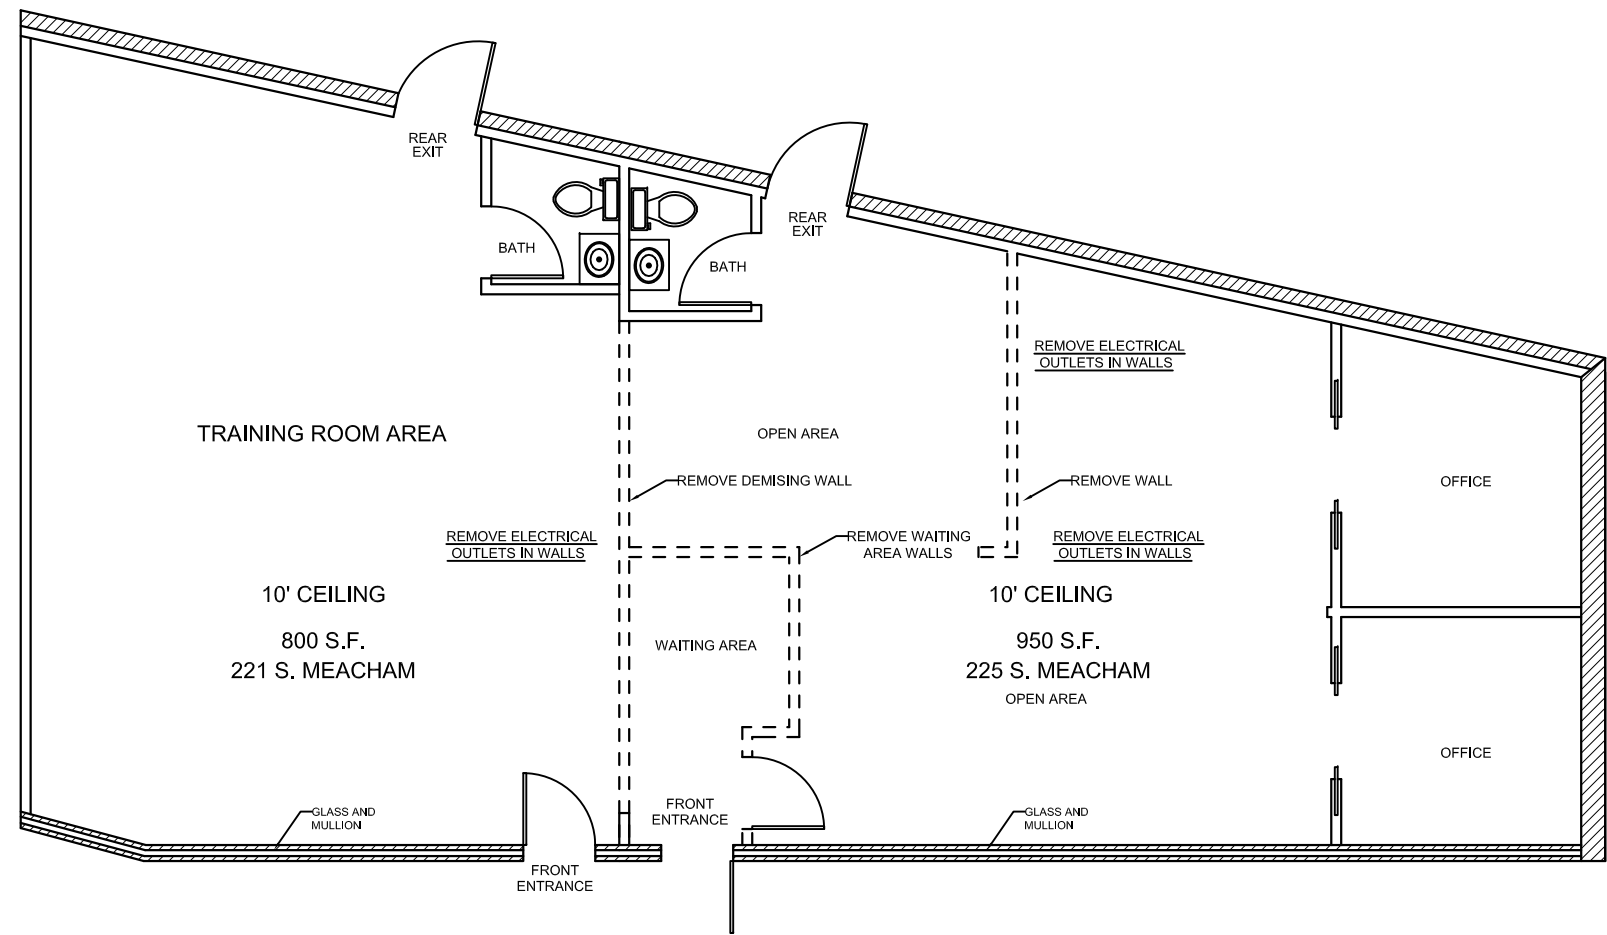

**1** EXISTING / DEMO PLAN  
Scale: 1/8" = 1' - 0"

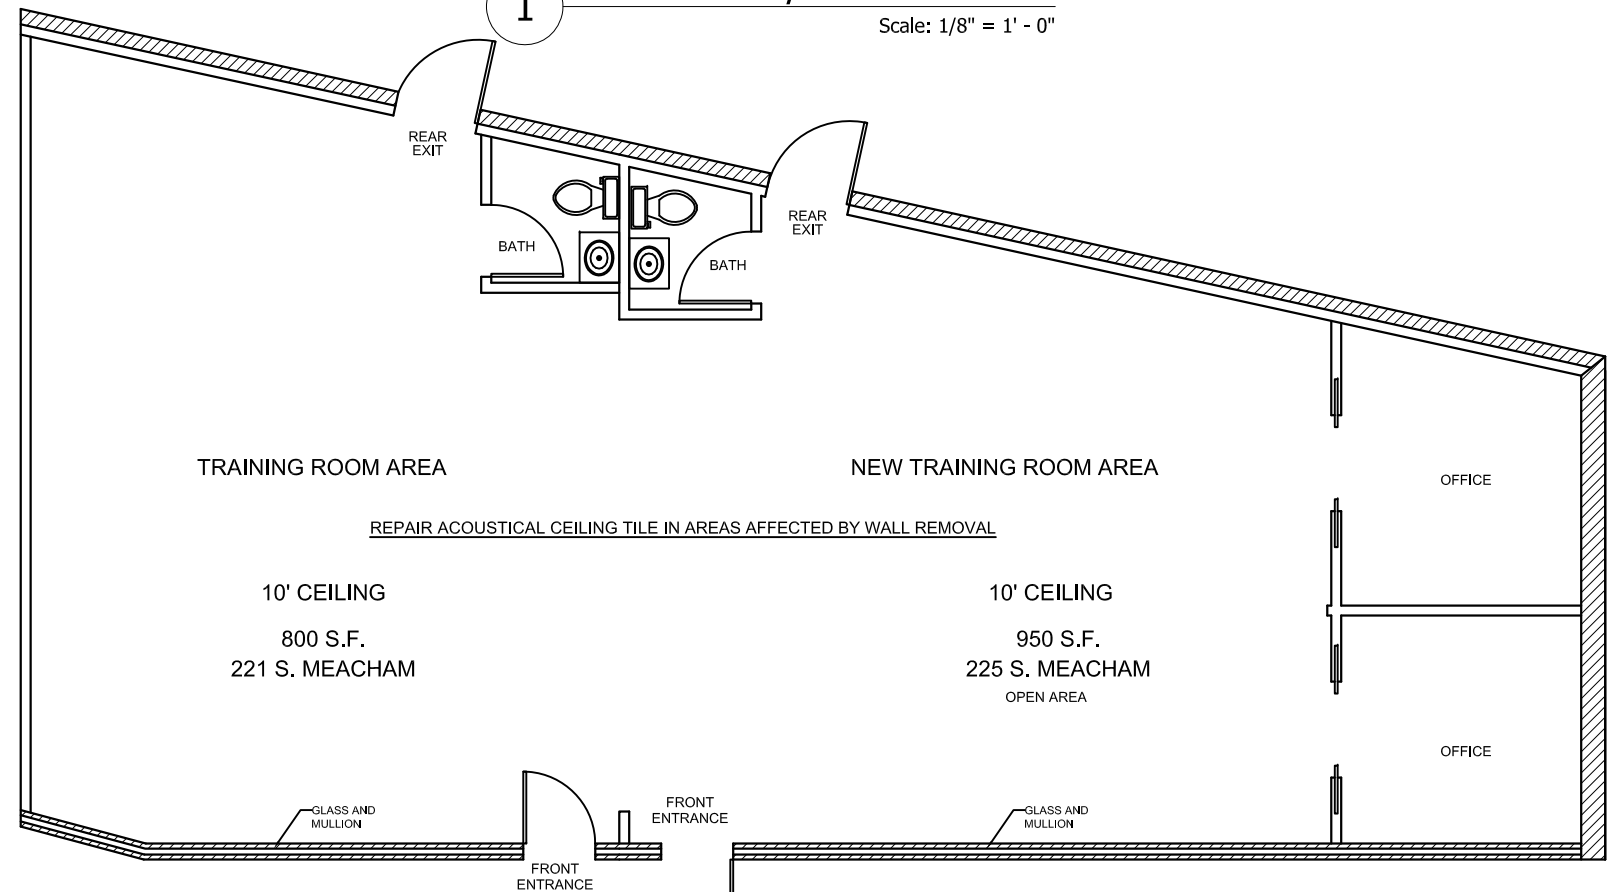

**2** PROPOSED FLOOR PLAN  
Scale: 1/8" = 1' - 0"

COMBINE 221 & 225 S. MEACHAM  
EXISTING & PROPOSED PLAN

221 - 225 S. MEACHAM RD.  
SCHAUMBURG, IL.

SHEET 1 OF 2

A-1