


Base Height 36
Total Height 91


EXISTING MDP				
150A 3 Ø 208V				
1	20A	LIGHTING	LIGHTING	20A 2
3	20A	RECEPTACLES	RECEPTACLES	20A 4
5	20A	RECEPTACLES	RECEPTACLES	20A 6
7	20A	RECEPTACLES	LIGHTING	20A 8
9	20A	LIGHTING	LIGHTING	20A 10
10	20A	BATHROOM REC.		12
13	20A	WATER COOLER	NEW AIR CONDITIONING	30A 14
15	15A	LIGHTING		16
17	30A	WATER HEATER	AIR CONDITIONING	30A 18
19				20
21	20A	LIGHTING	LIGHTING	20A 22
23	20A	LIGHTING	LIGHTING	20A 24
25	20A	LIGHTING	TELEPHONE REC.	15A 26
27	20A	LIGHTING	TELEPHONE REC.	15A 28
29	20A	LIGHTING	RECEPTACLES	20A 30
31	20A	LIGHTING	RECEPTACLES	20A 32
33	20A	LIGHTING	LIGHTING	20A 34
35	20A	LIGHTING		36
37	20A	RECEPTACLES	HEAT	60A 38
39	20A	RECEPTACLES		40
41	20A	RECEPTACLES	EMERGENCY LTS	20A 42

LIGHTING FIXTURE SCHEDULE	
MARK	TYPE
A	MATCH EXISTING
B	MATCH EXISTING
C	MATCH EXISTING
E	MATCH EXISTING
X	MATCH EXISTING

ELECTRICAL LEGEND	
SYMBOL	DESCRIPTION
▽	TELEPHONE OUTLET
⊕	DUPLEX RECEPT.
⊕	DUPLEX RECEPT. ABOVE BASE CABINET

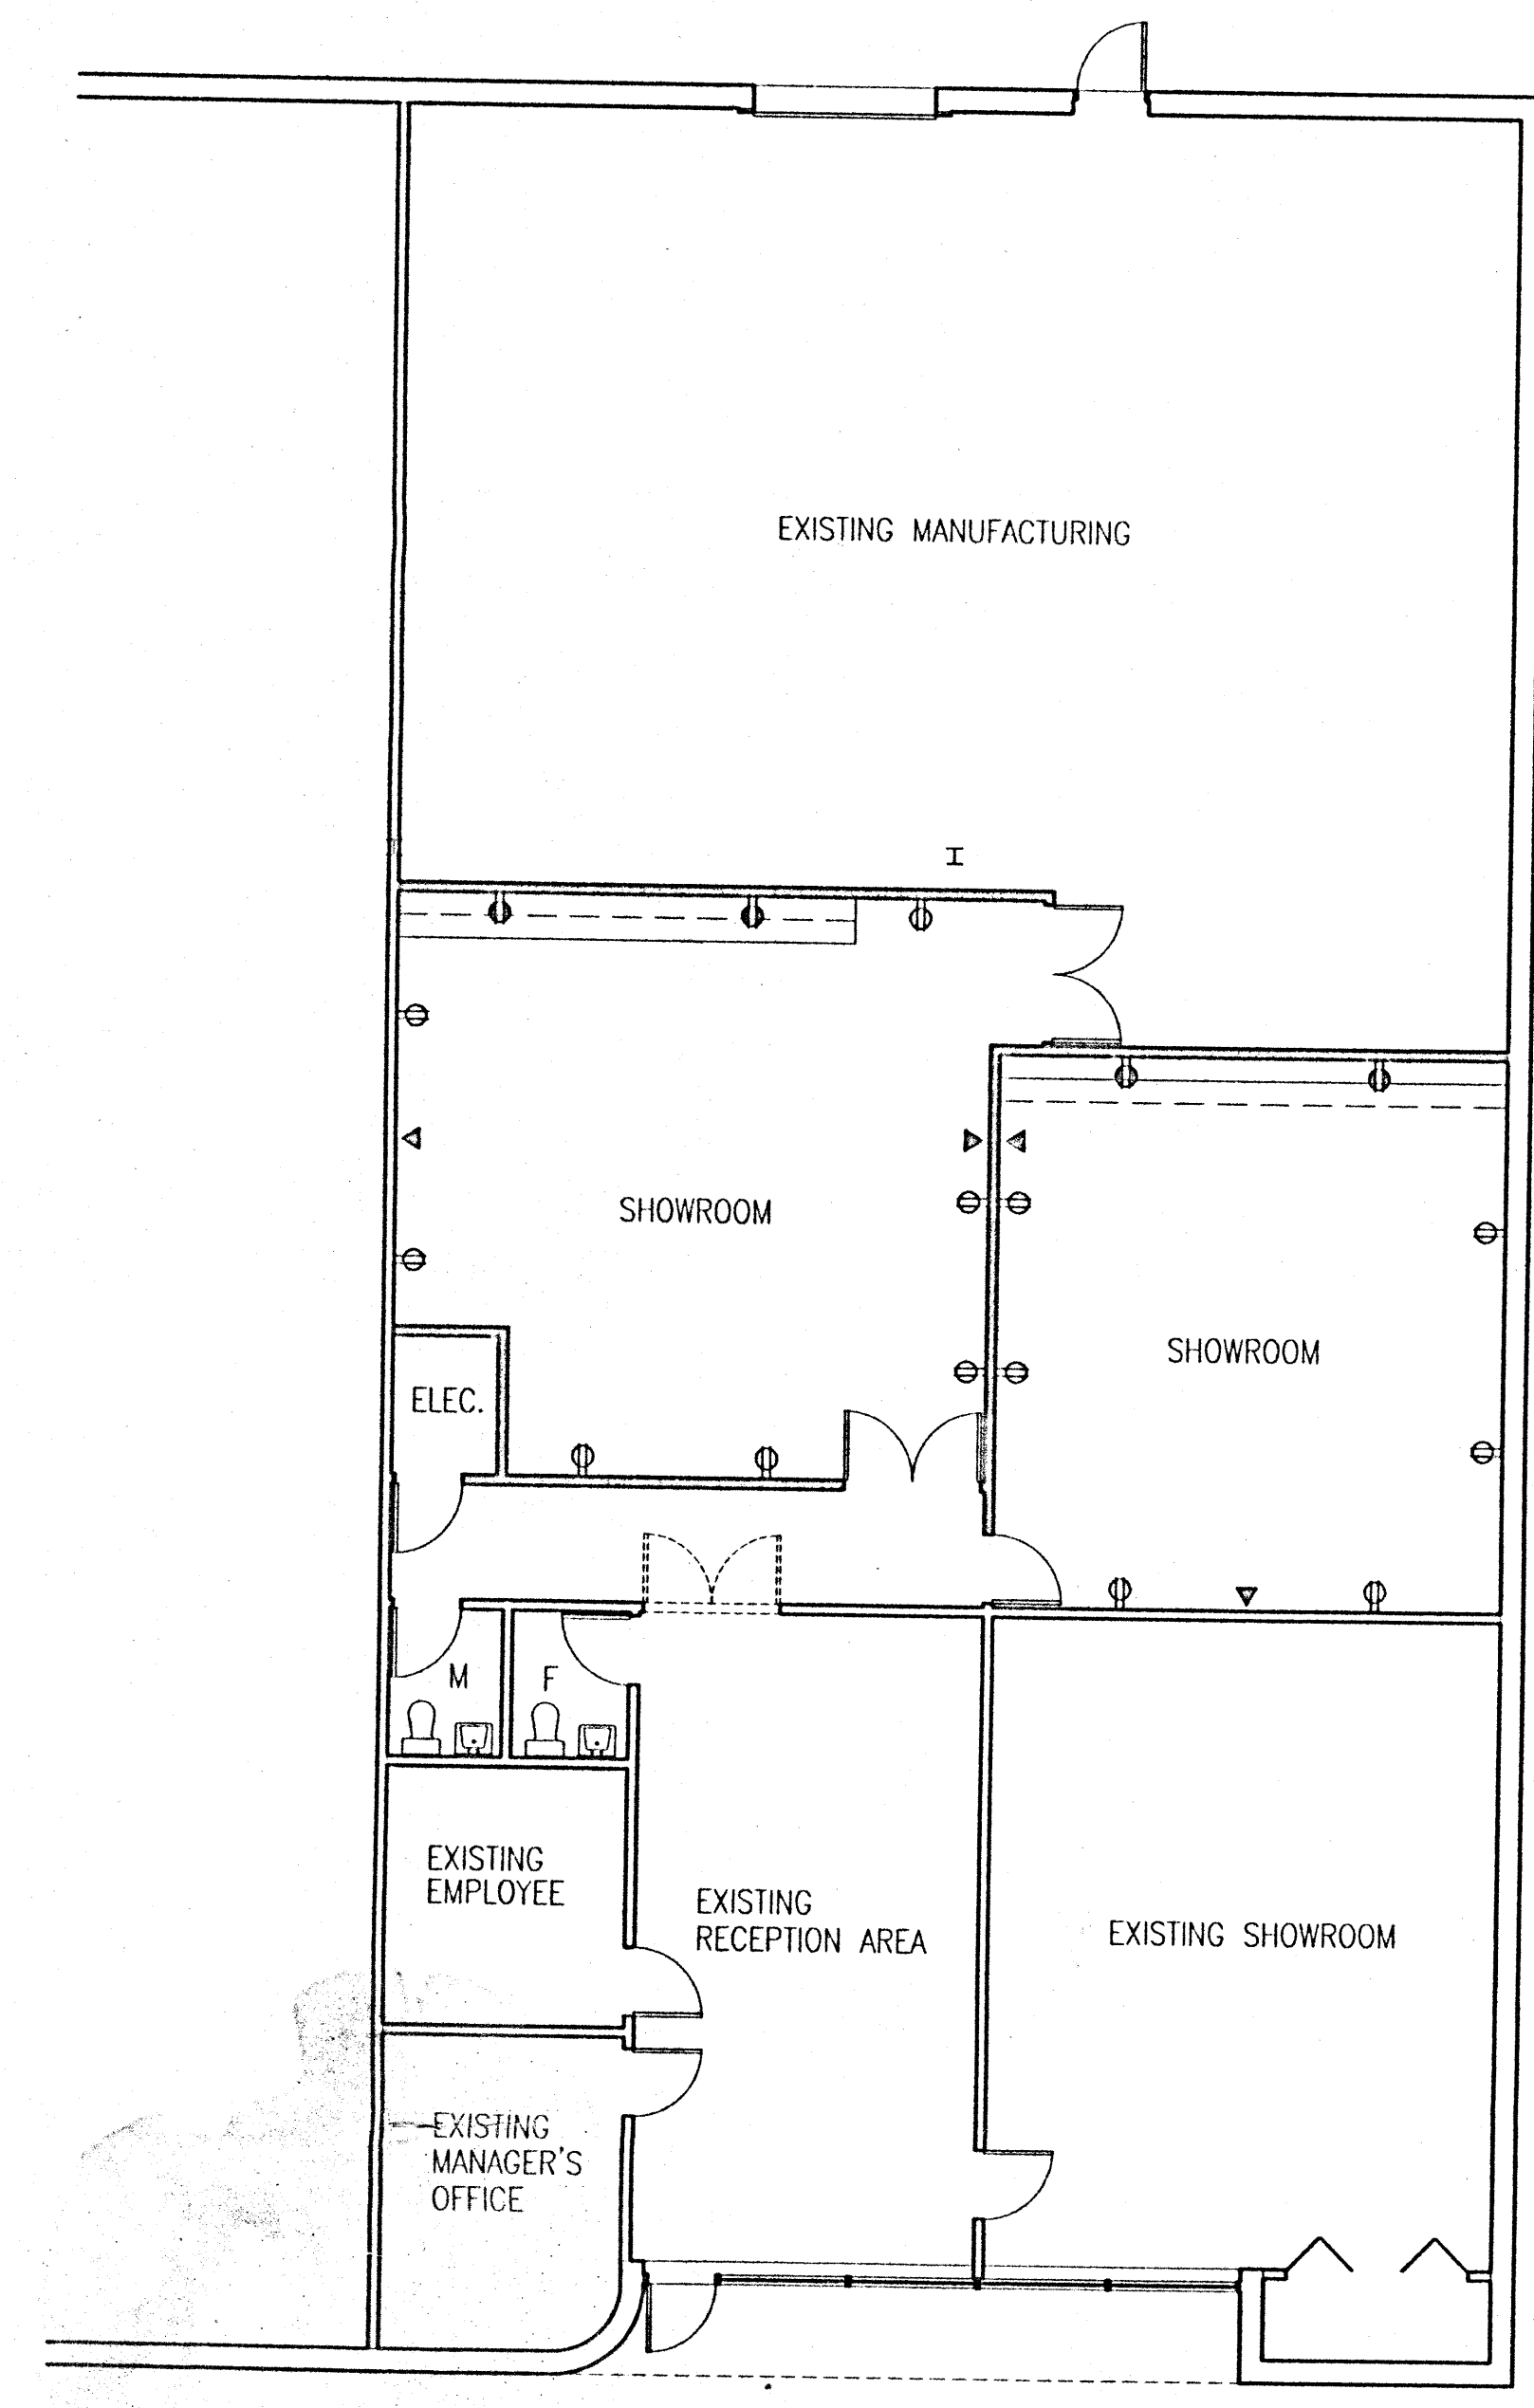

POWER WIRING PLAN
SCALE 1/8" = 1'-0"

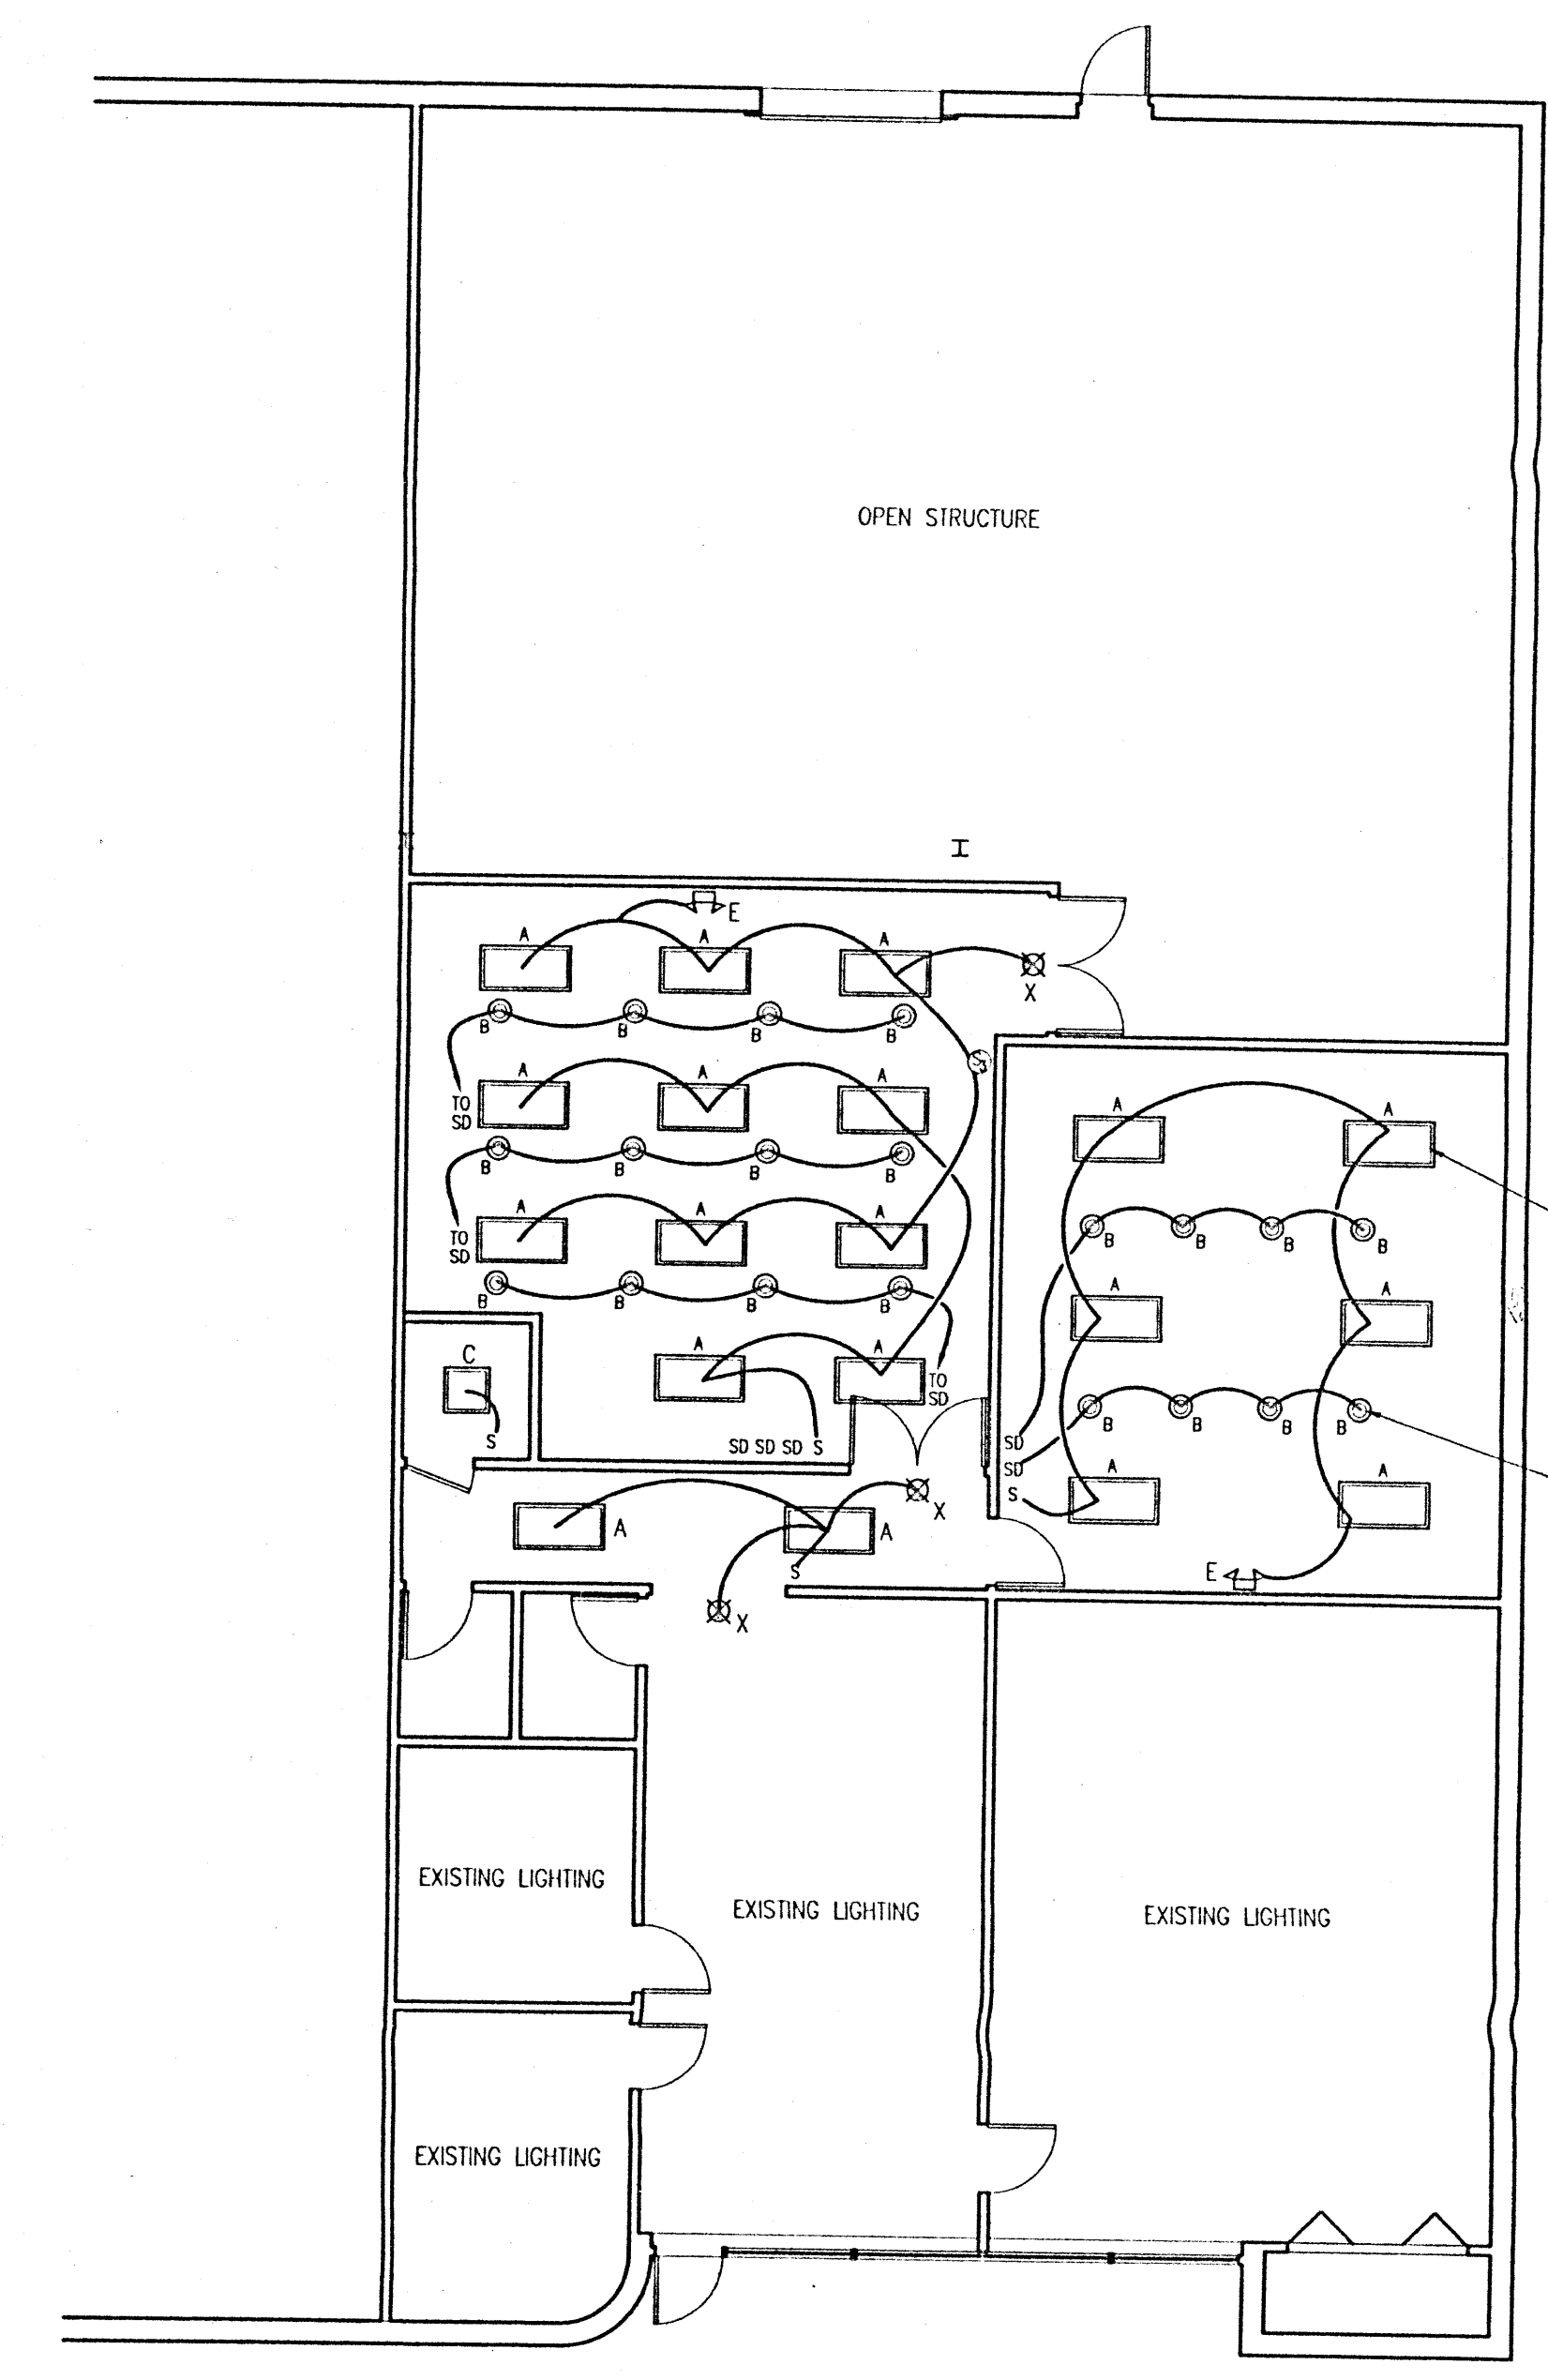

LIGHTING PLAN
SCALE 1/8" = 1'-0"

TYPICAL TYPE A FIXTURE
2 X 4 4 LAMP LAY-IN
FIXTURE (MATCH EXISTING)

TYPICAL RECESSED DOWNLIGHT
(MATCH EXISTING)

MACKIE JOHNSON ARCHITECT
 803 S. W. 10TH ST., SUITE 100
 CONOVER, NORTH CAROLINA 28628
 PHONE 828-464-1028 • FAX 828-468-4469
 EMAIL MACKIEJOHNSON@WORLDNET.ATT.NET

THESE DRAWINGS ARE THE PROPERTY OF
 MACKIE JOHNSON ARCHITECT, P.A.
 THEY MAY NOT BE REPRODUCED OR REUSED
 WITHOUT THE WRITTEN PERMISSION.
 USE WITHOUT PERMISSION IS A VIOLATION
 OF NORTH CAROLINA GENERAL STATUTES.

PROJECT
 INTERIOR RENOVATIONS FOR
CULP SHOWROOMS
 HICKORY
 NORTH CAROLINA

SHEET
 ELECTRICAL PLAN
 SCALE 1/8" = 1'-0"

DATE
 6-9-00
 REVISIONS

SHEET NO
E1
 OF 1