
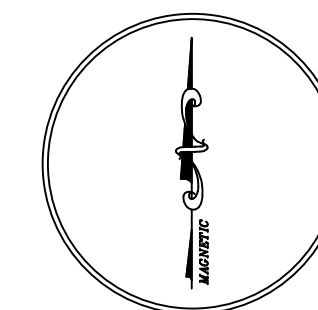
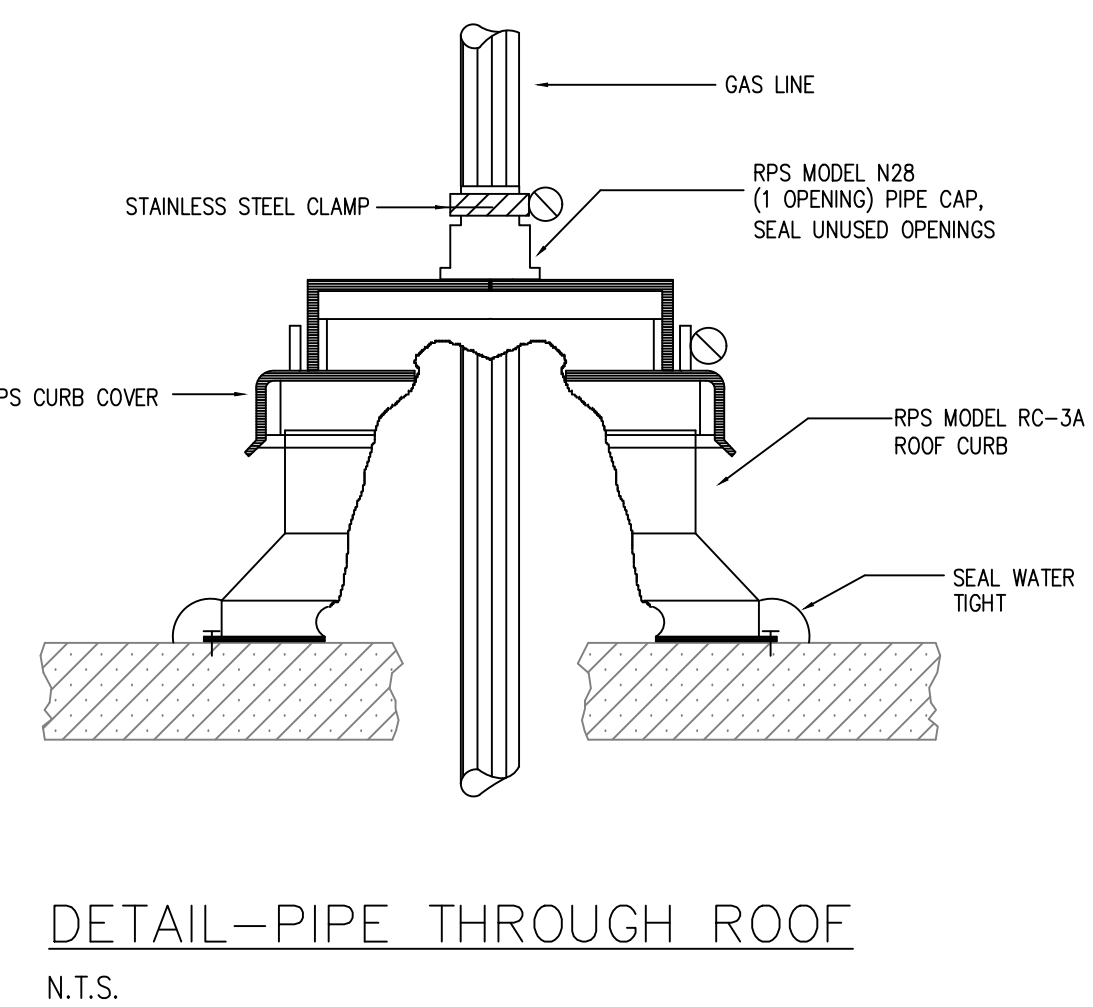
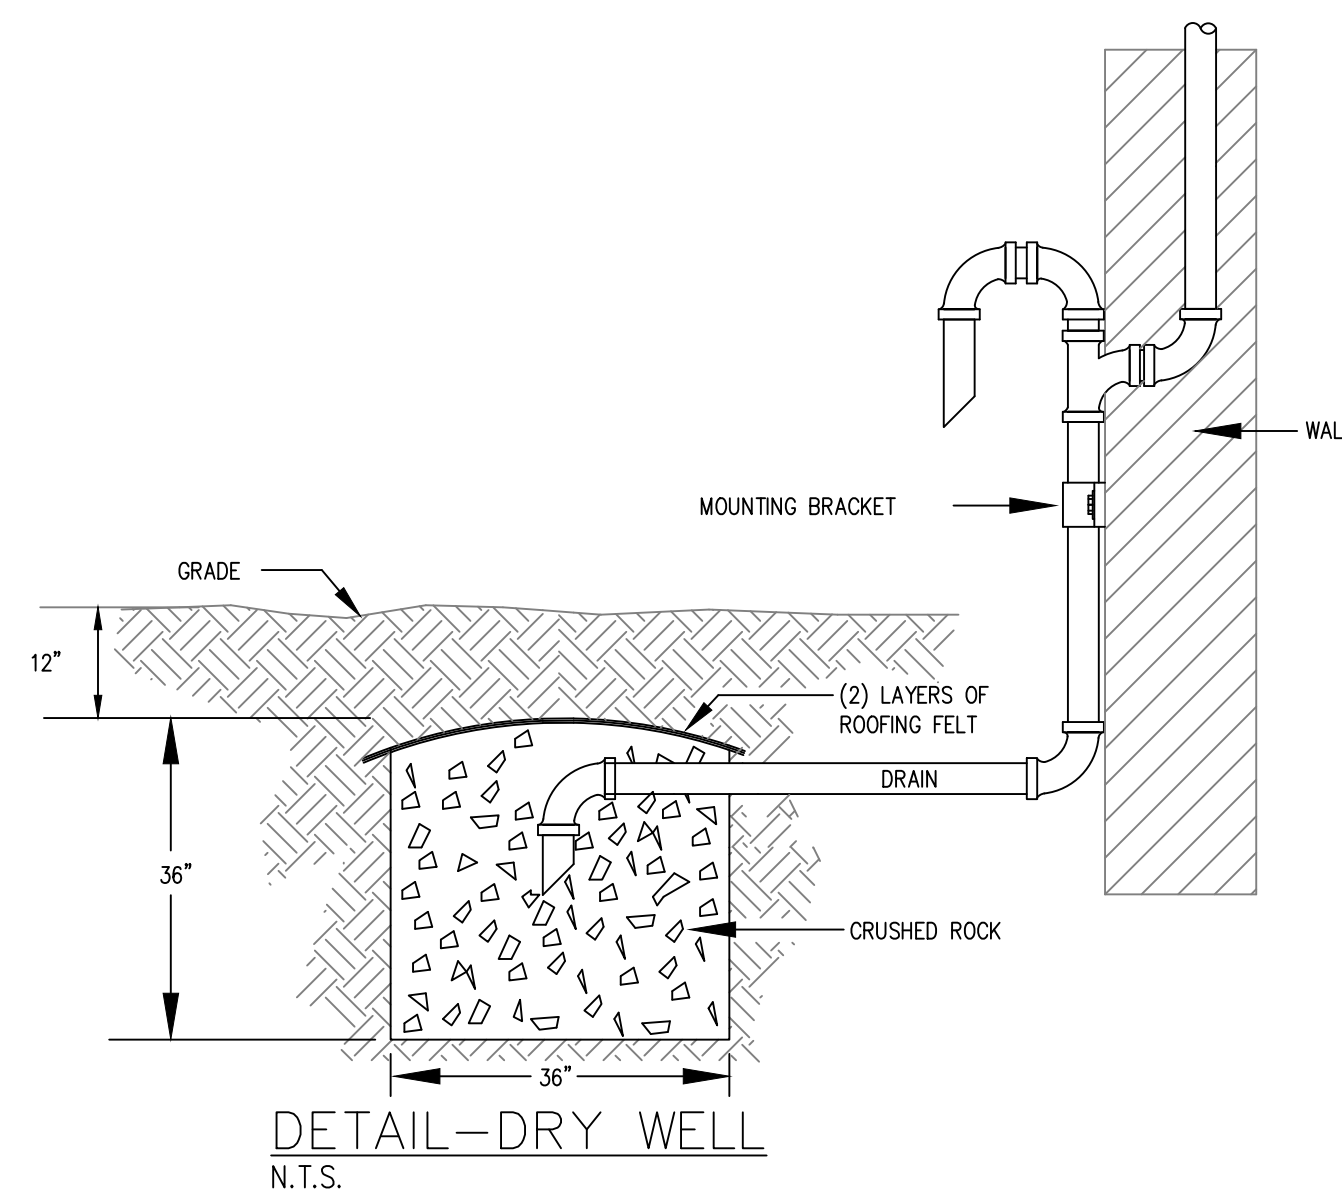
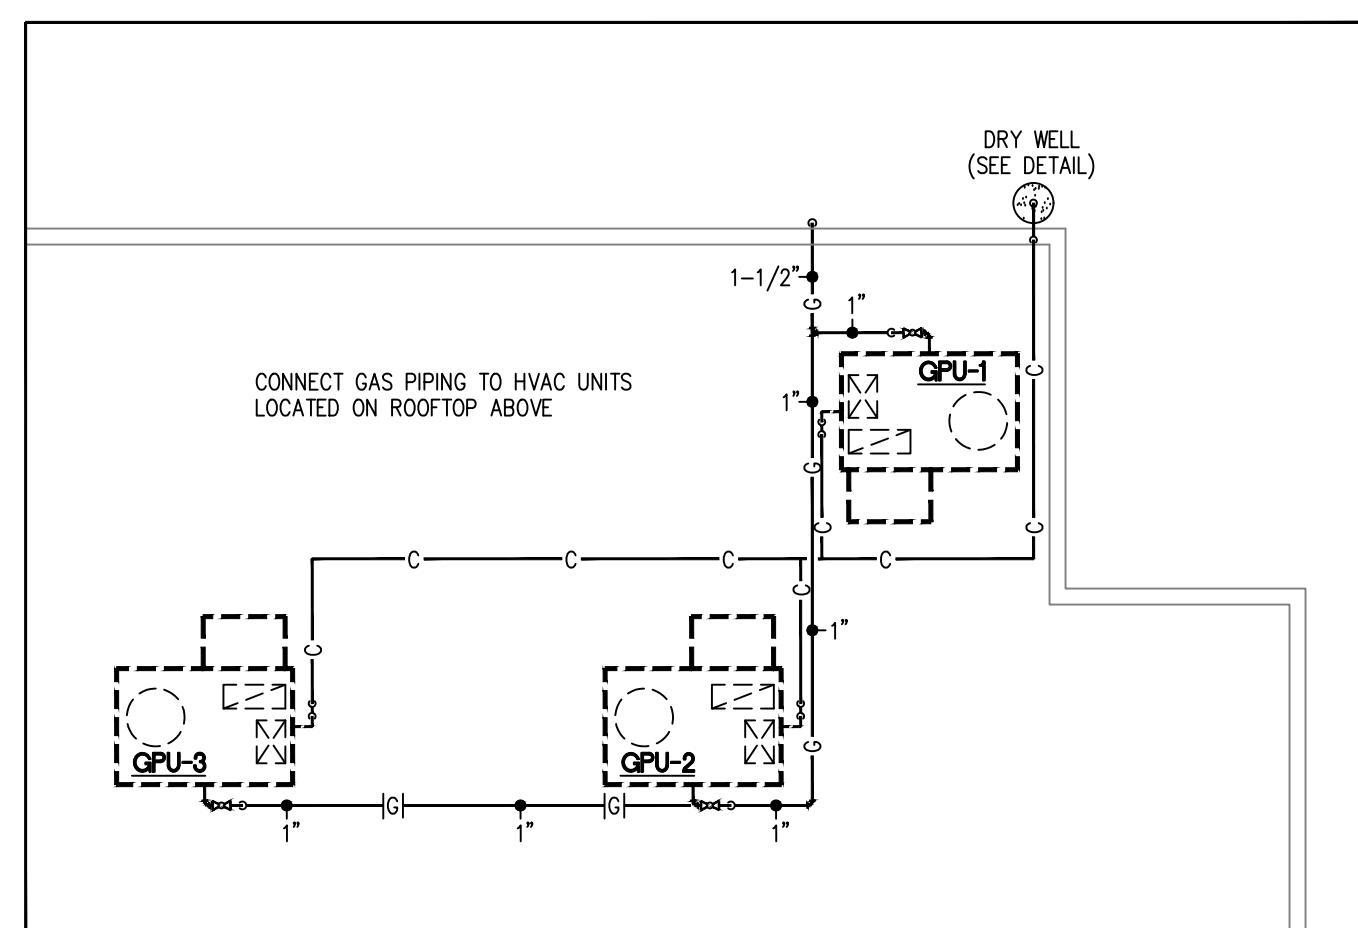


CONNECT 1-1/2" WATER DISTRIBUTION PIPE TO WATER SERVICE PIPE THIS APPROXIMATE LOCATION. SEE SITE PLAN FOR EXACT LOCATION. SITE CONTRACTOR TO PROVIDE BACKFLOW PREVENTER AS REQUIRED.

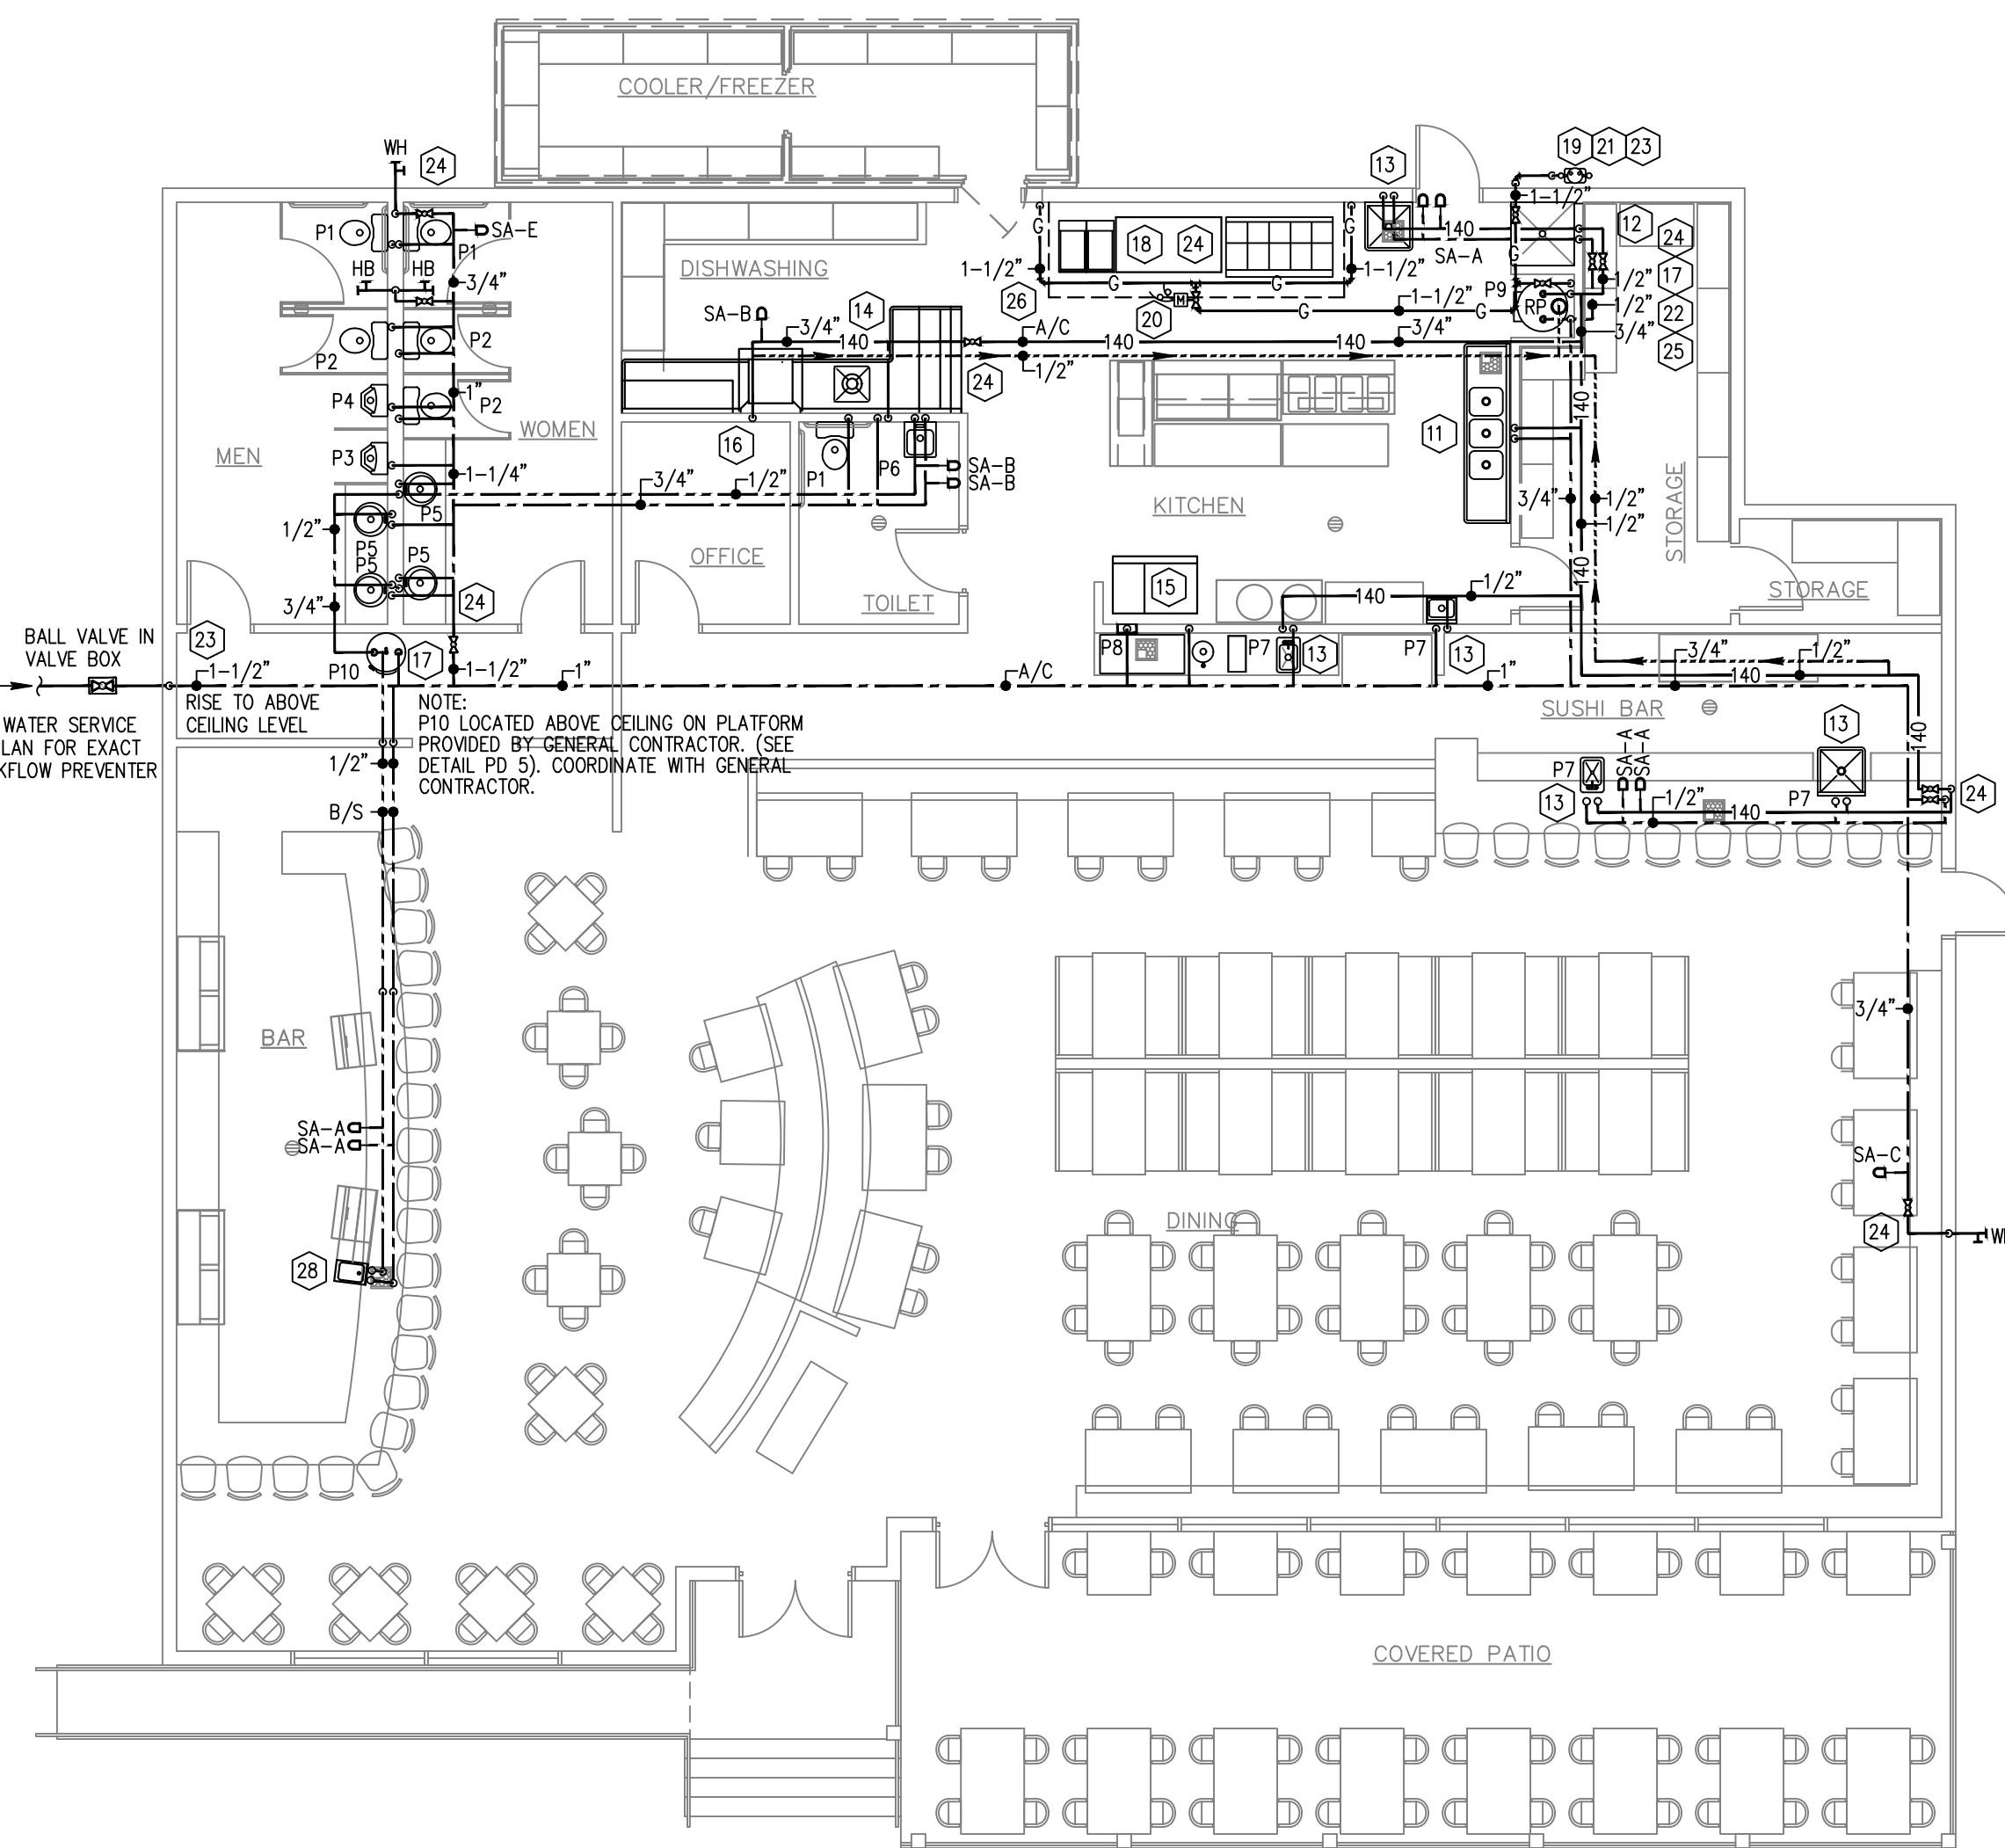



VISTA ENGINEERING, LLC
CONSULTING MECHANICAL ENGINEERING
530 S. SALUDA AVE. COLUMBIA, SC 29205
TEL: (803) 799-8900 FAX: (803) 799-8960
E-MAIL: VISTAENGINEERING@AOL.COM

REVISIONS	DATE
RELOCATED HVAC UNITS	1/30/09

APPROVALS	ARCHITECT:	ENGINEER:	DRAWN BY:	CHECKED BY:
	GDB	WZM	SCC	RRC

This drawing and the design shown thereon are the property of Vista Engineering, LLC. No part of this drawing, or any part of the design shown thereon, may be reproduced, stored in a retrieval system, or transmitted in any form or by any means, electronic, mechanical, photocopying, recording, or by any information storage and retrieval system, without the prior written permission of Vista Engineering, LLC.

ARCHITECTURA CONCEPTS AC, INC.
238 Stonewedge Drive Suite C - Columbia, South Carolina 29210
PH: (803) 790-8411 FAX: (803) 790-8413 EMAIL: arcon@archac.com

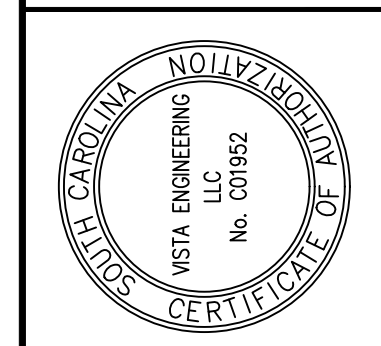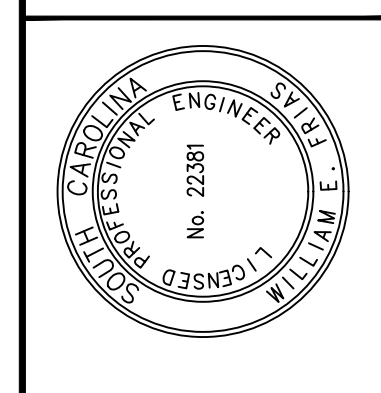

TSUNAMI
BOWER PARKWAY
COLUMBIA, SOUTH CAROLINA

SHEET NO.	P1
OF	4
JOB NO.	07167MP
DATE:	10/29/07