




DEMO PLAN

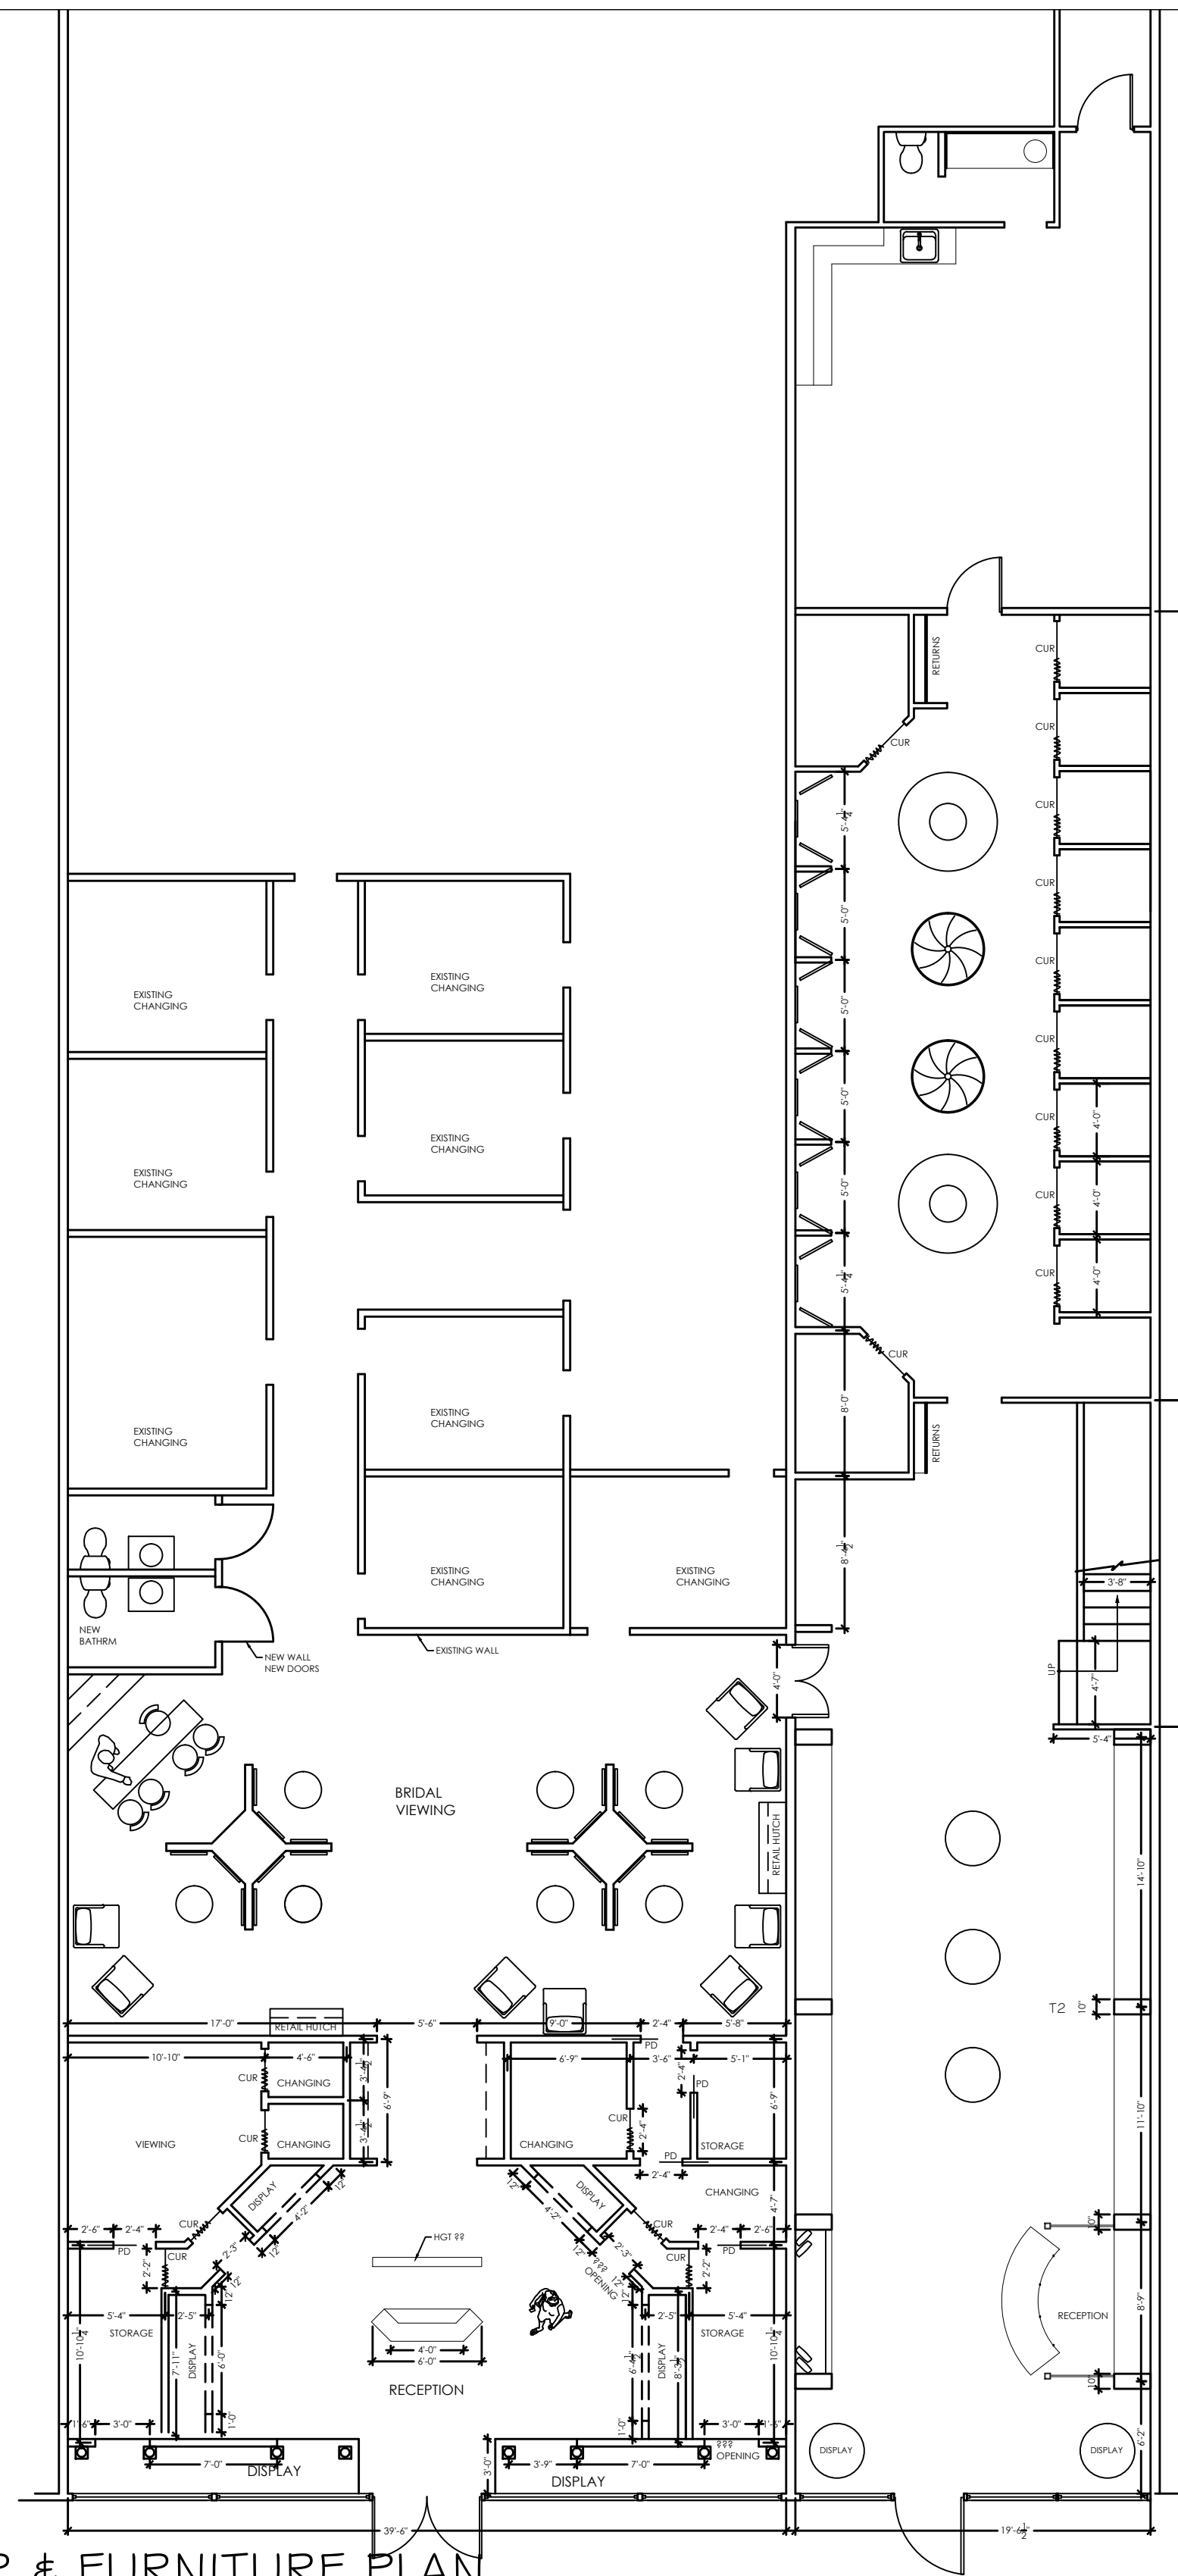


FLOOR & FURNITURE PLAN

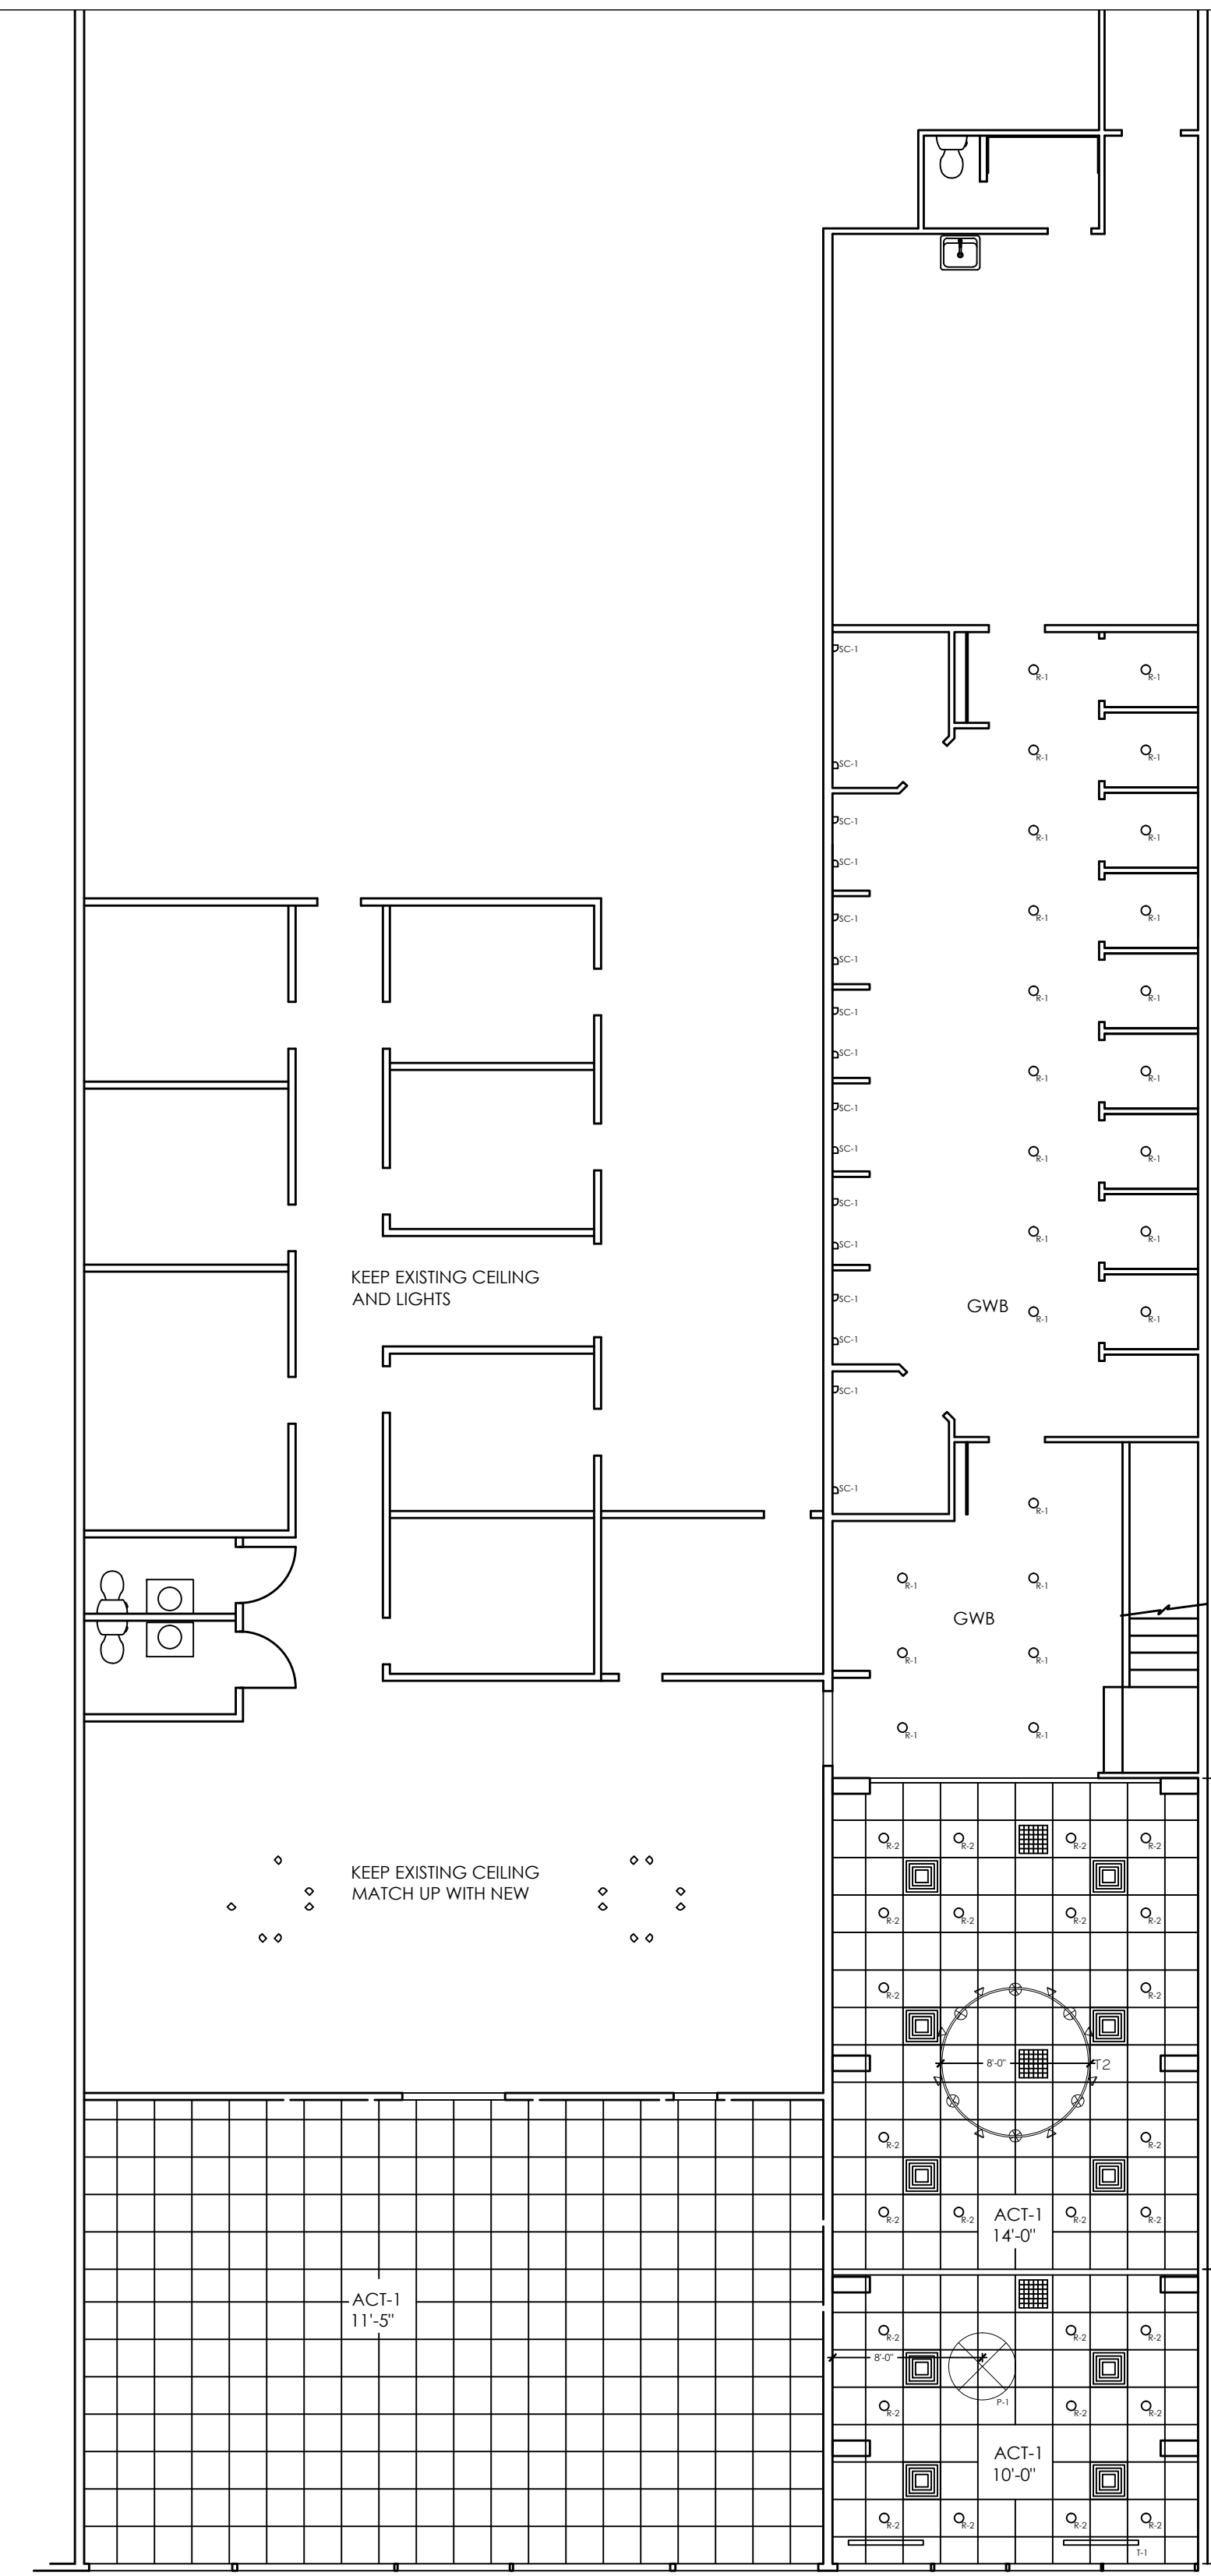

CEILING & LIGHTING PLAN

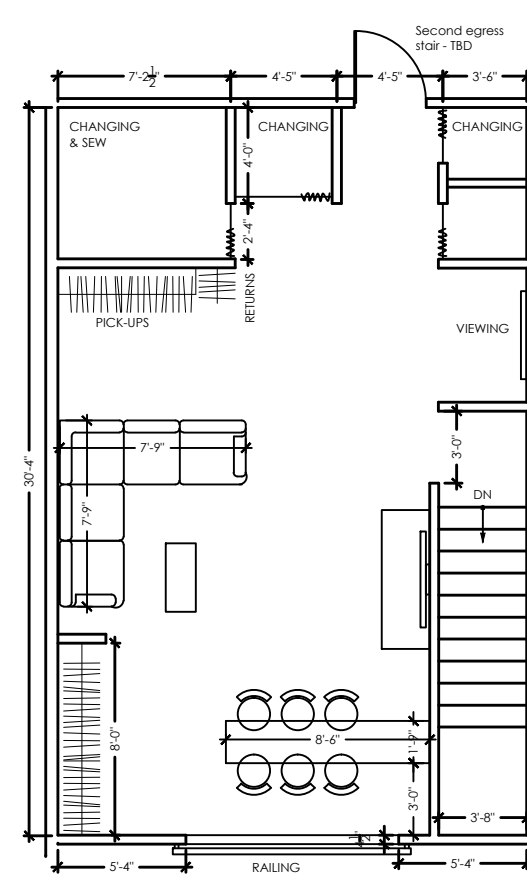

2ND FL & FURNITURE PLAN

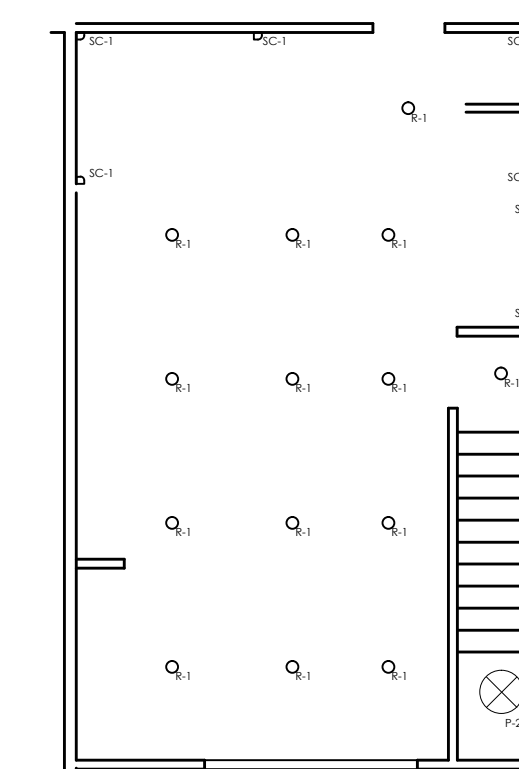

2ND FL CEILING & LIGHTING PLAN

REVISIONS:

GRAY CONSTRUCTION

TOBEY DESIGN GROUP

27 Ceres Street
 Portsmouth, NH 03801
 PH: 603.430.7621
 ttobey@tobeydesign.com
 www.tobeydesign.com

MADLINE DAUGHTER
 775 Layayette Rd
 Portsmouth NH 03801

TITLE:
 DEMO PLAN
 FLOOR PLAN
 FURNITURE PLAN
 CEILING
 LIGHTING PLAN

SCALE: Vanes = 1"=0'
 PROJECT NO.: 201604
 DATE: 5/23/16

ID. 1