


SUITE 800  
3452 SQ. FT

SUITE 600  
1660 SQ. FT

SUITE 400  
1854 SQ. FT

SUITE 200  
5790 SQ. FT

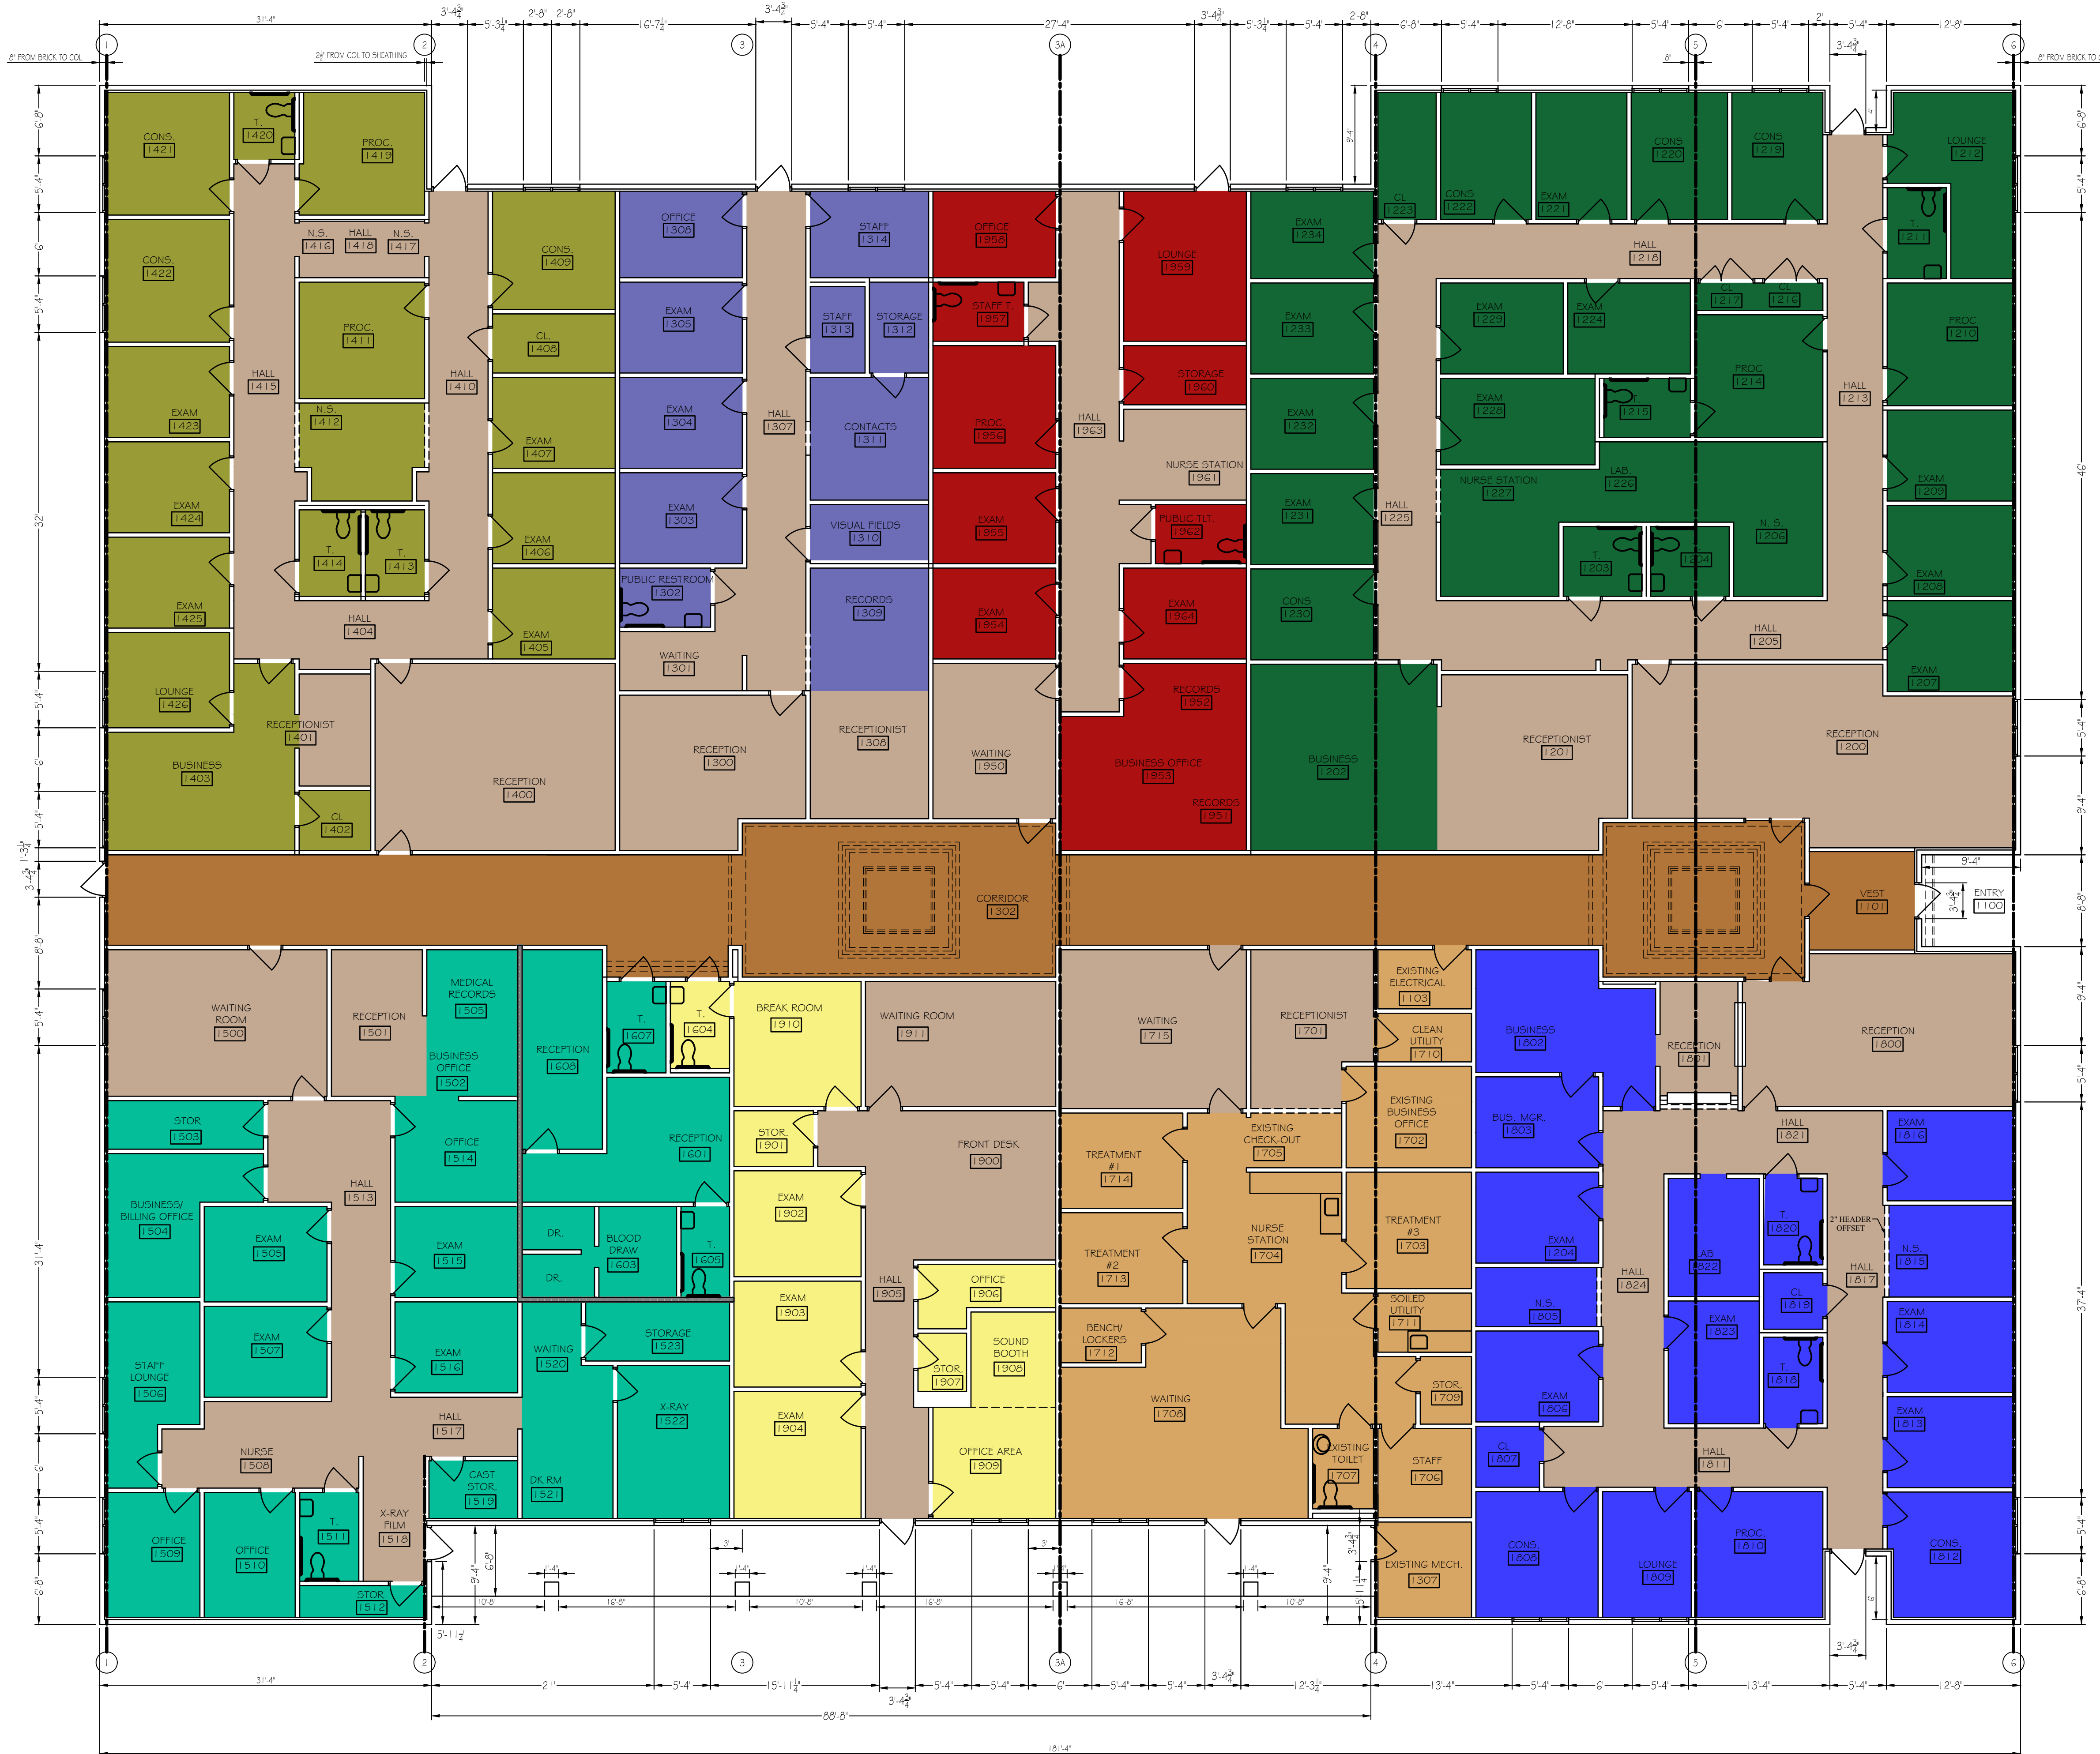


SUITE 900  
3142 SQ. FT

SUITE 500  
1539 SQ. FT

SUITE 300  
2070 SQ. FT

SUITE 100  
3287 SQ. FT

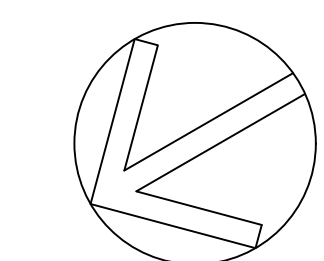

1 FLOOR PLAN  
A-1.3 SCALE: 1/8" = 1'-0"

REVISIONS					
Number	Date	Remarks	Number	Date	Remarks
X	00-00-00	N/A			

CONSULTANTS					
Number	Date	Remarks	Number	Date	Remarks

**CARTER WATKINS ASSOCIATES ARCHITECTS, INC.**  
 POST OFFICE BOX 1004  
 137 EAST WASHINGTON STREET  
 MONROE, GEORGIA 30655  
 Fax: 770-267-1064  
 email@carterwatkins.com www.carterwatkins.com

SEAL

CLEARVIEW REGIONAL  
 MEDICAL CENTER MOB  
 MONROE, GEORGIA

SHEET TITLE:  
 FLOOR PLAN  
 PRINTED: ~

NUMBER:  
**A-1.3**

NOT ISSUED FOR CONSTRUCTION. DATE: