



EXISTING FLOOR PLAN / SCALE: 1/4"=1'-0"

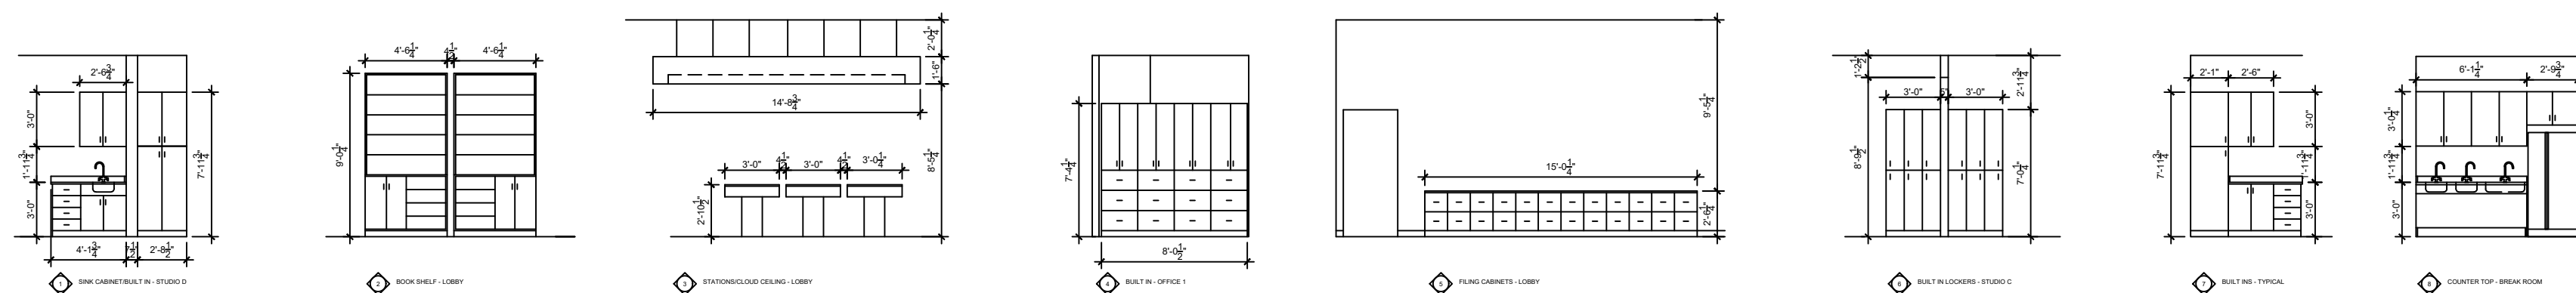


ELEVATIONS / SCALE: 1/8"=1'-0"

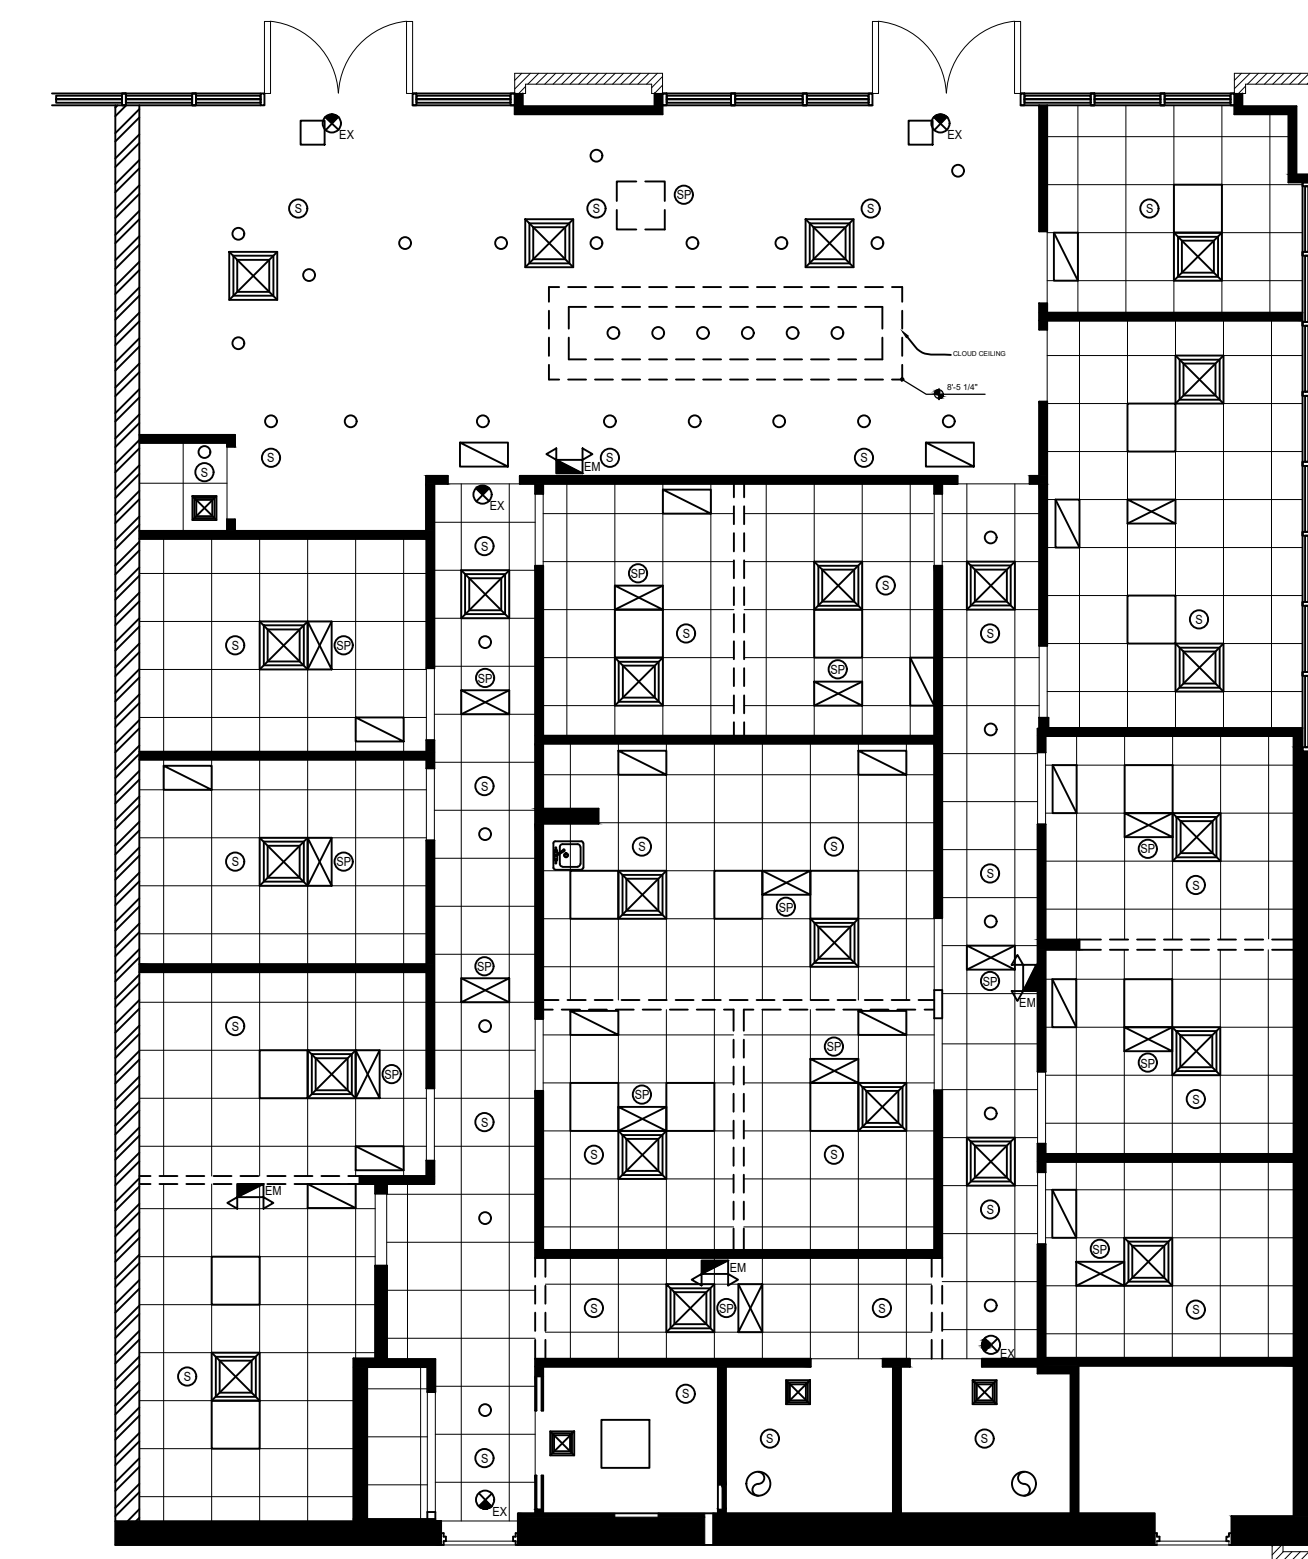

RCP LEGEND / SCALE: 1/8"=1'-0"

- 2X2 FLUORESCENT LIGHT
- ⊠ 2X2 REGISTER
- ⊠ 1X2 REGISTER
- ⊠ 1X2 RETRAN
- ⊠ 1X1 REGISTER
- 1X1 ACCESS
- 2X2 ACCESS
- EXT. SIGN
- ⊠ EMERGENCY LIGHT
- ⊠ SPEAKER
- ⊠ SPRINKLER
- ⊠ VENT FAN UNIT

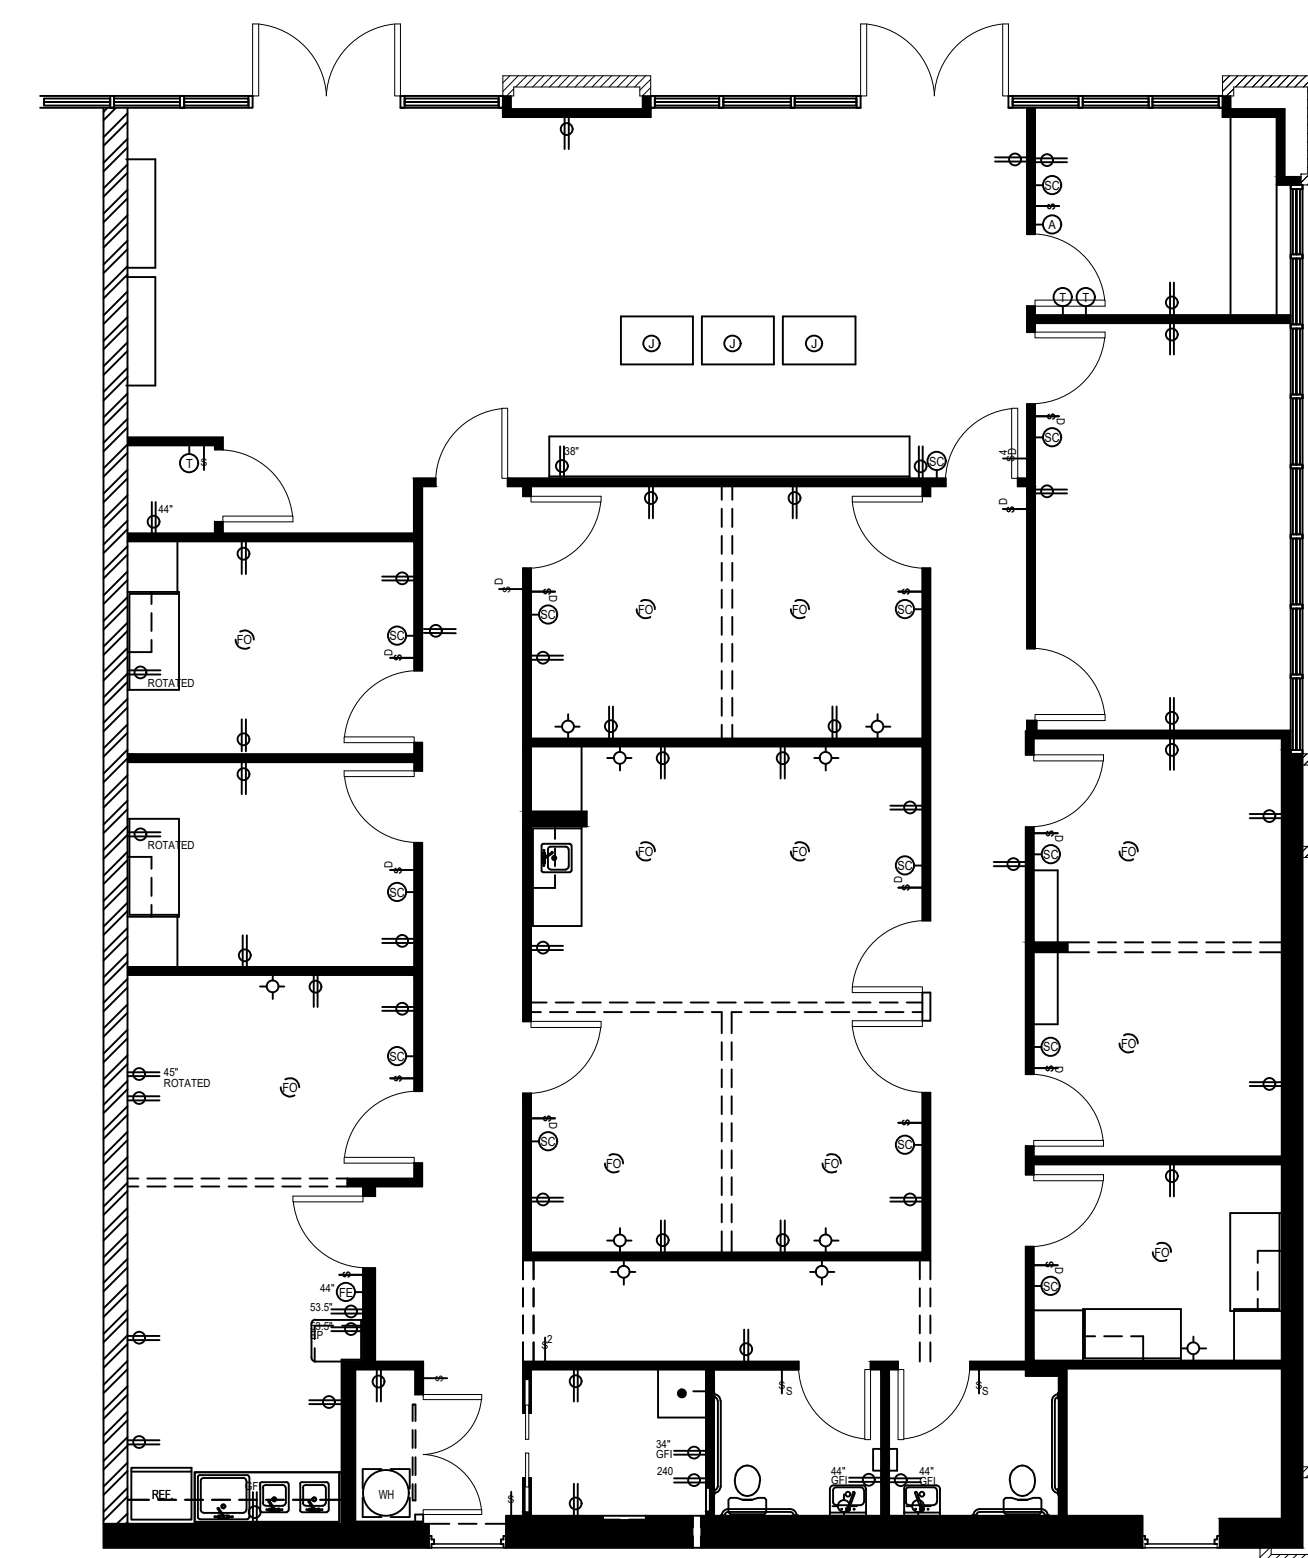

ELECTRICAL LEGEND / SCALE: 1/8"=1'-0"

- ⊠ 110V DUPLEX OUTLET
- ⊠ A.F. DUPLEX OUTLET 110V DUPLEX OUTLET
- ⊠ DIMMER OUTLET 110V DUPLEX OUTLET
- ⊠ SINGLE POLE SWITCH
- ⊠ SINGLE POLE SWITCH DIMMER
- ⊠ SINGLE POLE SWITCH 4 SWITCH DIMMER
- ⊠ SINGLE POLE SWITCH SENSOR
- ⊠ FIRE EXTINGUISHER
- ⊠ ALARM
- ⊠ SPEAKER CONTROL
- ⊠ THERMOSTATE
- ⊠ FLOOR OUTLET
- ⊠ JUNCTION BOX (FLOOR)
- ⊠ SURFACE MOUNT LIGHT
- 4X2 FLUORESCENT LIGHT

ISSUE DATE:
07.22.2020

ALL DRAWINGS ARE
REPRESENTATIONAL ONLY

Quinlan Crossing
5145 RR620 North, Suite F-110
Austin, TX 78732

fyi designs
COMMERCIAL • RESIDENTIAL
HOSPITALITY • MULTI-FAMILY
8868 RESEARCH BLVD. STE. 406
AUSTIN, TEXAS 78758
P. 5 1 2 . 2 1 6 . 9 4 8 2

DRAWN BY: JB

SCALE: AS NOTED

DESIGN PLANS ARE
PROVIDED FOR THE FAIR
USE BY THE CLIENT
AND/OR HIS
CONTRACTOR IN
COMPLETING THIS
PROJECT. DESIGN
PLANS REMAIN THE
PROPERTY OF
FYI DESIGNS.

FLOOR PLAN(S)

SHEET:

1