

REVISIONS		
NO.	DATE	BY

DESERT DESIGNS
 ARCHITECTS & INTERIORS
 14157 S. GILBERT DR. SUITE 900
 PALM DESERT, CA 92260
 P: 760-864-2882
 F: 760-864-2883

CATHEDRAL CITY, CALIFORNIA


BEYOND BALISAGE

PROJECT

DRAWN BY: MSJ
CHECKED BY: MSJ
DATE: 11-14-17
SCALE: 1/4"=1'-0"
JOB NO.: B0001
SHEET

K-1

FOODSERVICE EQUIPMENT SCHEDULE		
NO.	DESCRIPTION	MANUFACTURER
1	1 REFRIGERATED BACKBAR	TRUE MANUFACTURE
2	1 REFRIGERATED BACKBAR	TRUE MANUFACTURE
3	1 CASH MONITOR	BY ORDER
4	1 POS SYSTEM	BY ORDER
5	1 ICE BIN	BY ORDER
6	1 ICE BIN	BY ORDER
7	1 CORNER FILLER, INSIDE 30"	ARONNE
8	1 WORKBOARD WITH TRIPLE SINKS	ARONNE
9	1 DRABBOARD	ARONNE
10	1 HAND SINK W/ TOWEL DISPENSER	ARONNE
11	1 ICE CUBER	HOSHIZAKI
12	1 ICE STORAGE BIN	HOSHIZAKI
13	1 HAND SINK, W/ SOAP & TOWEL DISP	HOSHIZAKI
14	1 COUNTER, PLATE	CSW
15	1 REFRIGERATED BACKBAR	TRUE MANUFACTURE
16	1 COUNTER, PLATE	CSW
17	1 COUNTER, PLATE	CSW
18	1 COUNTER, PLATE	CSW
19	1 COUNTER, PLATE	CSW
20	1 SHELF, PASS-THRU	EAGLE GROUP
21	1 SINK, TRIP	CSW
22	1 SINK, TRIP	CSW
23	1 SINK, TRIP	CSW
24	1 EXHAUST VENTILATOR	CSW
25	1 REFRIGERATOR, SLAB/UNDERCOUNTER	TRUE MANUFACTURE
26	1 GRILL, WOOD-FIRED	AZTEC
27	1 HOTPLATE, GAS-FIRED	AMERICAN RANGE
28	1 WORK TABLE	METAL MASTERS
29	1 OVEN, CONVECTION, FRENCH DOORS	BUCKE
30	1 CHEF REFRIGERATOR	HOSHIZAKI
31	1 CASH REGISTER	BY ORDER
32	1 SINK, TRIP	CSW
33	1 HAND SINK, W/ SOAP & TOWEL DISP	CSW
34	1 DISHWASHER	JACKSON FRIGO
35	1 THREE COMPARTMENT SINK	CSW
36	1 FREEZER, REACH-IN	HUNDER
37	1 FREEZER, REACH-IN	HUNDER
38	1 WALK-IN COOLER	TRUE MANUFACTURE
39	1 REMOTE CONDENSING UNIT	COMMERCIAL COOLING
40	1 EVAPORATOR COIL	ADT 1065
41	1 SHRELVING UNIT	TRONIER

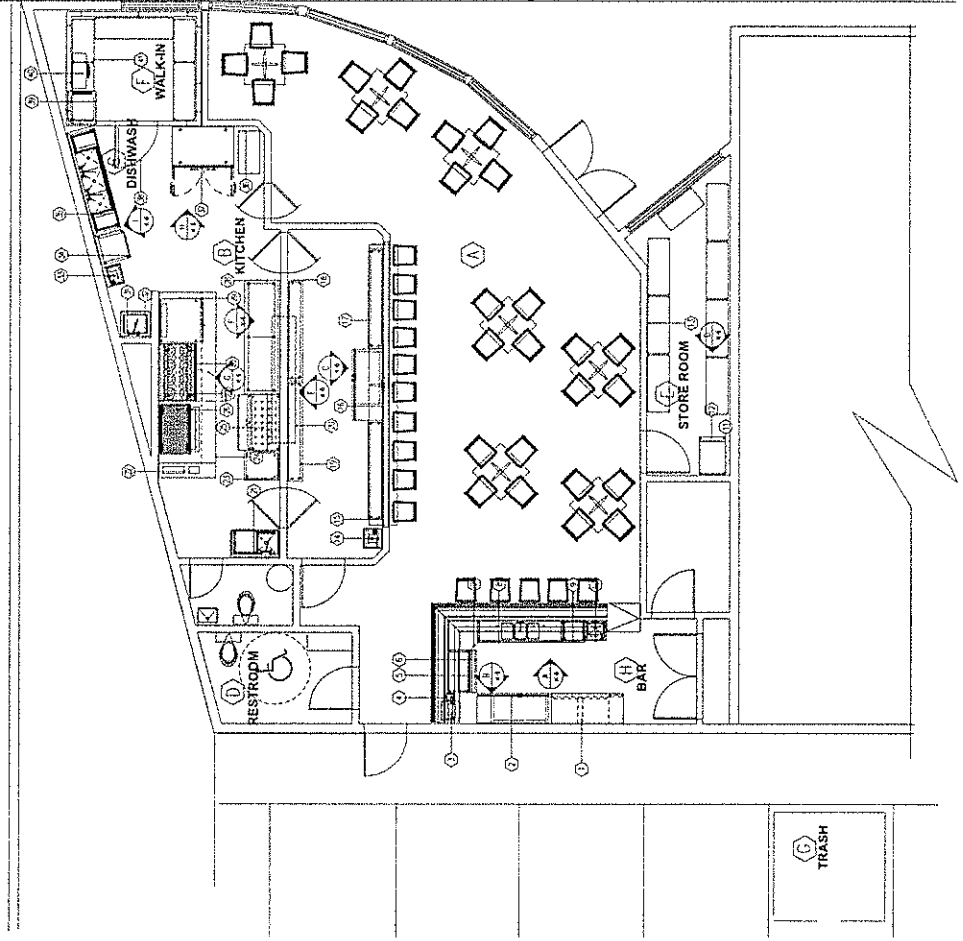

EQUIPMENT FLOOR PLAN

FOODSERVICE EQUIPMENT SCHEDULE												
LINE	ITEM DESCRIPTION	ELECTRICAL	FLAMES	KV	A	VOLTS	DIRECT	COOL	HEAT	WASTE	SEAM	REMARKS
1	1 REFRIGERATED BACKBAR	114			120	1	X					
2	1 REFRIGERATED BACKBAR	114			120	1	X					
3	1 CASH MONITOR	20			120	1	X					
4	1 POS PRINTER	20			120	1	X					
5	1 ICE BIN									1-1/2"		
6	1 BOTTLE RACK									1-1/2"		
7	1 CORNER FILLER, 1/2" X 20"									1-1/2"		
8	1 WORKSINK WITH THREE SINKS									1-1/2"		
9	1 DRAINBOARD									1-1/2"		
10	1 HAND SINK W/ TONEL DISPENSER									1-1/2"		
11	1 ICE CUBER	127			120	1	X			1-1/2"		
12	1 ICE STORAGE BIN									1-1/2"		
13	LOI SHELVE UNIT									1-1/2"		SEE DRAWINGS FOR CONNECTION DETAILS
14	1 HAND SINK, W/SOAP & TONEL DISP									1-1/2"		
15	1 COUNTER PLATE									1-1/2"		
16	1 REFRIGERATED BACKBAR	114			120	1	X					SEE DRAWINGS FOR CONNECTION DETAILS
17	1 COUNTER PLATE									1-1/2"		
18	1 COUNTER PLATE									1-1/2"		
19	1 COUNTER PLATE									1-1/2"		
20	1 SHELF, PASS-THRU									1-1/2"		
21	2 SHIP, PREPARESS SYSTEM	40			120	1	X					
22	1 WORK TABLE									1-1/2"		
23	1 PANTRY SHELVE UNIT									1-1/2"		
24	1 REFRIGERATOR, SALAD/SANDWICH BISTOP	70			120	1	X					
25	1 GRILL, WOOD-FIRED									1-1/2"		
26	1 HOT PLATE, GAS-FIRED									1-1/2"		
27	1 WORK TABLE									1-1/2"		
28	1 OVEN, CONVECTION, FRENCH DOORS	80			120	1	X			1-1/2"		
29	1 CHFF REFRIGERATOR	114			120	1	X			1-1/2"		
30	1 FAUCET, SPASH-MOUNT									1-1/2"		
31	1 HAND SINK, W/SOAP & TONEL DISP									1-1/2"		
32	1 DISHWASHER	112			120	1	X			1-1/2"		SEE DRAWINGS FOR CONNECTION DETAILS
33	1 THREE COMPARTMENT SINK									1-1/2"		
34	1 FREEZER, REACH-IN	117			120	1	X			1-1/2"		
35	1 WALK-IN COOLER	115			120	1	X			1-1/2"		
36	1 REMOTE CONDENSING UNIT	59			120	1	X			1-1/2"		
37	1 EVAPORATOR COIL	18			120	1	X			1-1/2"		
38	1 SHELVE UNIT									1-1/2"		

REVISIONS		
NO.	DATE	BY
1		
2		
3		
4		
5		
6		
7		
8		
9		
10		

DESERT DESIGNS
KITCHEN & BAR DESIGN
11111 DESERT BLVD
PALM DESERT CA 92260
C-948-992-4382
714-965-6485

CATHEDRAL CITY, CALIFORNIA

BEYOND BALISAGE

PROJECT	
DRAWN BY: MSJ	
CHECKED BY: MSJ	
DATE: 11-06-17	
SCALE: 1"=1'-0"	
JOB NO: BB001	
SHEET	

K-2

SCHEDULE SHEET

DESERT DESIGN
KITCHEN & BAR DESIGN
45-775 OCOTILLO DR. # 5
PALM DESERT CA 92260
C: 949-845-3582
F: 760-965-6889

BEYOND BALISAGE

PROJECT

DRAWN BY: MSJ
CHECKED BY: MSJ
DATE: 11-06-17
SCALE: 1"=1'-0"
JOB NO.: 8B001
SHEET

ELECTRICAL FLOOR PLAN

1	7/1L AMPS, 120V, 1-PH SERVICE, NEMA 5-15P, DUPLEX ELECTRIC OUTLET AT 16'-0" AFF FOR SERVICE TO ITEM 1, REFRIGERATOR, BEER COOLER,
2	7/1L AMPS, 120V, 1-PH SERVICE, NEMA 5-15P, DUPLEX ELECTRIC OUTLET AT 16'-0" AFF FOR SERVICE TO ITEM 2, REFRIGERATOR, BEER COOLER,
3	7/1L AMPS, 120V, 1-PH SERVICE, NEMA 5-15P, DUPLEX ELECTRIC OUTLET AT 16'-0" AFF FOR SERVICE TO ITEM 3, REFRIGERATOR, BEER COOLER,
4	1/3T AMPS, 120V, 1-PH SERVICE, 3-POD MONITOR, STUB OUT WALL AT 5'-6"-AFF AND
5	1/3T AMPS, 120V, 1-PH SERVICE, STUB OUT WALL AT 5'-6"-AFF AND
6	1/3T AMPS, 120V, 1-PH SERVICE, STUB OUT WALL AT 5'-6"-AFF AND
7	1/3T AMPS, 120V, 1-PH SERVICE, STUB OUT WALL AT 5'-6"-AFF AND
8	1/3T AMPS, 120V, 1-PH SERVICE, STUB OUT WALL AT 5'-6"-AFF AND
9	1/3T AMPS, 120V, 1-PH SERVICE, STUB OUT WALL AT 5'-6"-AFF AND
10	1/3T AMPS, 120V, 1-PH SERVICE, STUB OUT WALL AT 5'-6"-AFF AND
11	1/3T AMPS, 120V, 1-PH SERVICE, STUB OUT WALL AT 5'-6"-AFF AND
12	1/3T AMPS, 120V, 1-PH SERVICE, STUB OUT WALL AT 5'-6"-AFF AND
13	1/3T AMPS, 120V, 1-PH SERVICE, STUB OUT WALL AT 5'-6"-AFF AND
14	1/3T AMPS, 120V, 1-PH SERVICE, STUB OUT WALL AT 5'-6"-AFF AND
15	1/3T AMPS, 120V, 1-PH SERVICE, STUB OUT WALL AT 5'-6"-AFF AND
16	1/3T AMPS, 120V, 1-PH SERVICE, STUB OUT WALL AT 5'-6"-AFF AND
17	1/3T AMPS, 120V, 1-PH SERVICE, STUB OUT WALL AT 5'-6"-AFF AND
18	1/3T AMPS, 120V, 1-PH SERVICE, STUB OUT WALL AT 5'-6"-AFF AND
19	1/3T AMPS, 120V, 1-PH SERVICE, STUB OUT WALL AT 5'-6"-AFF AND
20	1/3T AMPS, 120V, 1-PH SERVICE, STUB OUT WALL AT 5'-6"-AFF AND
21	1/3T AMPS, 120V, 1-PH SERVICE, STUB OUT WALL AT 5'-6"-AFF AND
22	1/3T AMPS, 120V, 1-PH SERVICE, STUB OUT WALL AT 5'-6"-AFF AND
23	1/3T AMPS, 120V, 1-PH SERVICE, STUB OUT WALL AT 5'-6"-AFF AND
24	1/3T AMPS, 120V, 1-PH SERVICE, STUB OUT WALL AT 5'-6"-AFF AND
25	1/3T AMPS, 120V, 1-PH SERVICE, STUB OUT WALL AT 5'-6"-AFF AND
26	1/3T AMPS, 120V, 1-PH SERVICE, STUB OUT WALL AT 5'-6"-AFF AND
27	1/3T AMPS, 120V, 1-PH SERVICE, STUB OUT WALL AT 5'-6"-AFF AND
28	1/3T AMPS, 120V, 1-PH SERVICE, STUB OUT WALL AT 5'-6"-AFF AND
29	1/3T AMPS, 120V, 1-PH SERVICE, STUB OUT WALL AT 5'-6"-AFF AND
30	1/3T AMPS, 120V, 1-PH SERVICE, STUB OUT WALL AT 5'-6"-AFF AND
31	1/3T AMPS, 120V, 1-PH SERVICE, STUB OUT WALL AT 5'-6"-AFF AND
32	1/3T AMPS, 120V, 1-PH SERVICE, STUB OUT WALL AT 5'-6"-AFF AND
33	1/3T AMPS, 120V, 1-PH SERVICE, STUB OUT WALL AT 5'-6"-AFF AND
34	1/3T AMPS, 120V, 1-PH SERVICE, STUB OUT WALL AT 5'-6"-AFF AND
35	1/3T AMPS, 120V, 1-PH SERVICE, STUB OUT WALL AT 5'-6"-AFF AND
36	1/3T AMPS, 120V, 1-PH SERVICE, STUB OUT WALL AT 5'-6"-AFF AND
37	1/3T AMPS, 120V, 1-PH SERVICE, STUB OUT WALL AT 5'-6"-AFF AND
38	1/3T AMPS, 120V, 1-PH SERVICE, STUB OUT WALL AT 5'-6"-AFF AND
39	1/3T AMPS, 120V, 1-PH SERVICE, STUB OUT WALL AT 5'-6"-AFF AND
40	1/3T AMPS, 120V, 1-PH SERVICE, STUB OUT WALL AT 5'-6"-AFF AND

5104

IT IS THE INTENTION OF THIS PLAN TO SHOW UTILITY REQUIREMENTS AND CONNECTION POINTS. DO NOT USE FOR ROUGHING-IN LOCATIONS. FOR ACTUAL ROUGHING-IN LOCATIONS REFER TO THE KITCHEN EQUIPMENT CONTRACTOR'S SHOP DRAWINGS.

ALL EQUIPMENT RECEPTACLES TO BE POLARIZED. PROVIDE STANDARD U-SLOT DUPLEX 3-WIRE GROUND TYPE RECEPTACLES FOR ALL GUILTLES.

1998, 1999, 2000, 2679, 26

ALL SERVICE FITTINGS (PEDISTAL TYPE) MOUNTED ON EQUIPMENT SURFACES WHERE INDICATED, SHALL BE PROVIDED BY THE KITCHEN EQUIPMENT CONTRACTOR AND CONNECTED BY THE ELECTRICAL CONTRACTOR.

ALL REFRIGERANT, CARBOHYDRAED WATER, AND GAS CO2 LINES IN UNOCCUPIED OR INACCESSIBLE AREAS SHALL BE RUN IN CONDUIT PROVIDED BY AND INSTALLED BY THE ELECTRICAL CONTRACTOR. ALL SUCH CONDUITS SHALL HAVE A MINIMUM OF 2" O.D. RADIUS SWEEPS WITH ENDS STEEPED UP A MINIMUM OF 4" ABOVE THE FINISHED FLOOR OR/OR WALL LINE, ETC.

PROVIDE REMOTE DISCONNECT SWITCH FOR MACHINES IN COMPRESSOR ROOM AND WITHIN 10'-0" OF ROOM DOOR, BY MEANS OF HOLDING COIL WIRING AND/OR LINE SWITCH.


EQUIP OR HOT FOOD RECEPICLES AND STRIP HEATERS SHALL BE PROVIDED AND WRED COMPLETE WITHIN THE FIXTURE BY THE KITCHEN EQUIPMENT CONTRACTOR. THE ELECTRICAL CONTRACTOR SHALL PROVIDE SERVICE AND MAKE THE CONNECTION.

ALL SWITCHES, EXCEPT FOR THOSE REQUIRED FOR SPECIAL

ELECTRICAL CONTRACTOR SHALL PROVIDE AND INSTALL CONTACTORS FOR BREAKING THE ELECTRICAL SERVICE TO ALL ELECTRICAL HEATED EQUIPMENT UNDER HOOD FROM THE FIRE EXTINGUISHER MICRO SWITCH. ELECTRICAL CONTRACTOR SHALL INSTALL RELAY FOR THE GAS SHUT-OFF VALVE.

LEGEND - ELECTRICAL CONNECTIONS

- | | |
|---|---|
|  | DUPLEX RECEPT., 20-AMP, 120-VOLT,
GROUND TYPE, HORIZONTAL MOUNT |
|  | SINGLE-POLE SWITCH, 20-AMP, 120-VOLT,
GROUND TYPE, HORIZONTAL MOUNT |
|  | SPECIAL PURPOSE OUTLET, 120-VOLT,
GROUND TYPE, HORIZONTAL MOUNT |
|  | SPECIAL PURPOSE OUTLET, 208/240-VOLT
AS INDICATED, GROUND TYPE, HORIZONTAL MOUNT |
|  | JUNCTION BOX |
|  | ELECTRICAL CONDUIT STUB AS INDICATED
FOR DIRECT CONNECTION |
|  | FLOOR/CEILING RECEPTACLE AS INDICATED |
|  | ISOLATED GROUND - FOR POS SYSTEM |
|  | WATERPROOF COVER AT RECEPTACLE |
|  | FIELD WIRING EXPOSED RACE |
|  | WATERPROOF CONDUIT |
|  | FIELD WIRING CONCEALED IN WALL |
|  | FIELD WIRING CONCEALED IN CEILING |

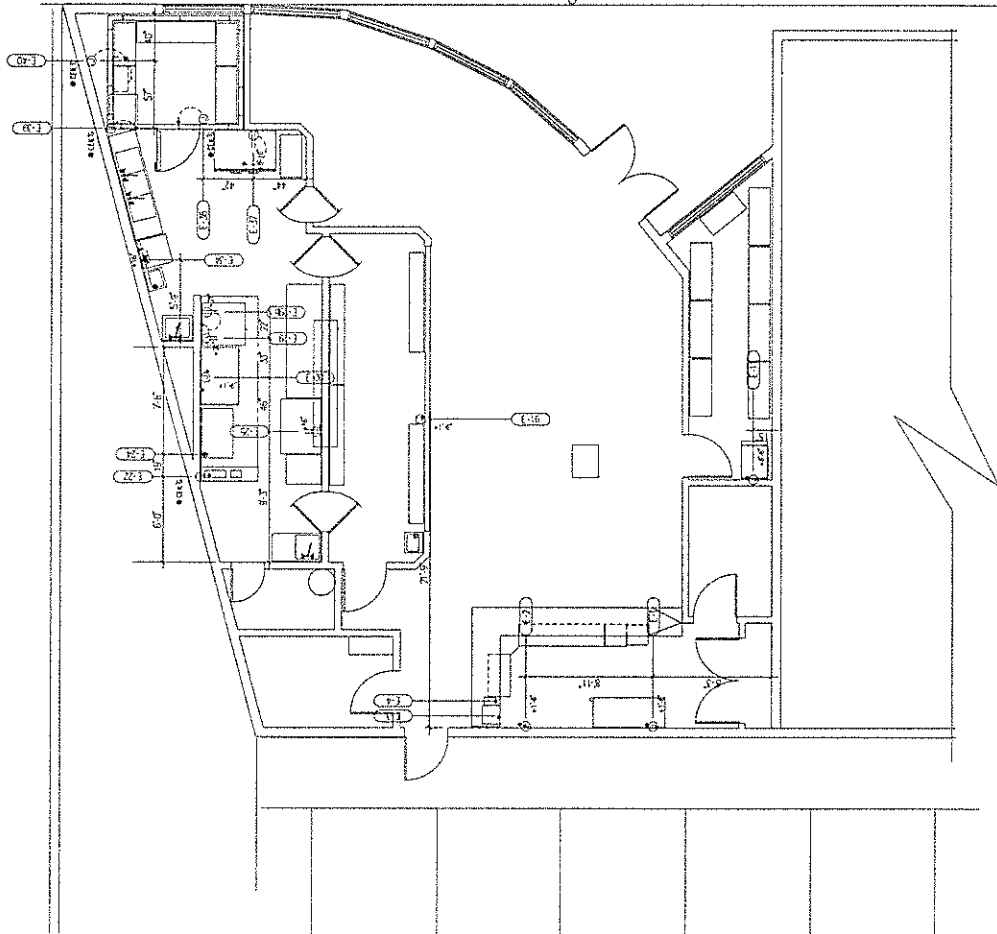

DESERT DESIGNS
KITCHEN & BAR DESIGN
45-775 OCOTILLO DR. # 9
PALM DESERT CA 92260
C: 949-945-3582
F: 760-565-6888

BEYOND BALISAGE

PROJECT |

DRAWN BY: MSJ

CHECKED BY: MSJ

DATE: 11-06-17

SCALE: 1"=1'-0"


JOB NO.: B0001

SHEET

K-4

LEGEND - PLUMBING CONNECTIONS

- HW-HOT WATER, OR CW-COLD WATER
- STEAM SUPPLY, OR C-CONDENSATE RETURN
- GAS SUPPLY
- WASTE, DIRECT-CONNECTED UNLESS NOTED "OPEN PIG"
- FLOOR SINK WITH HALF GATE UNLESS NOTED OTHERWISE
- FLOOR DRAIN
- FLOOR DRAIN W/ATTACHED FUNNEL
- FIELD CONNECTIONS

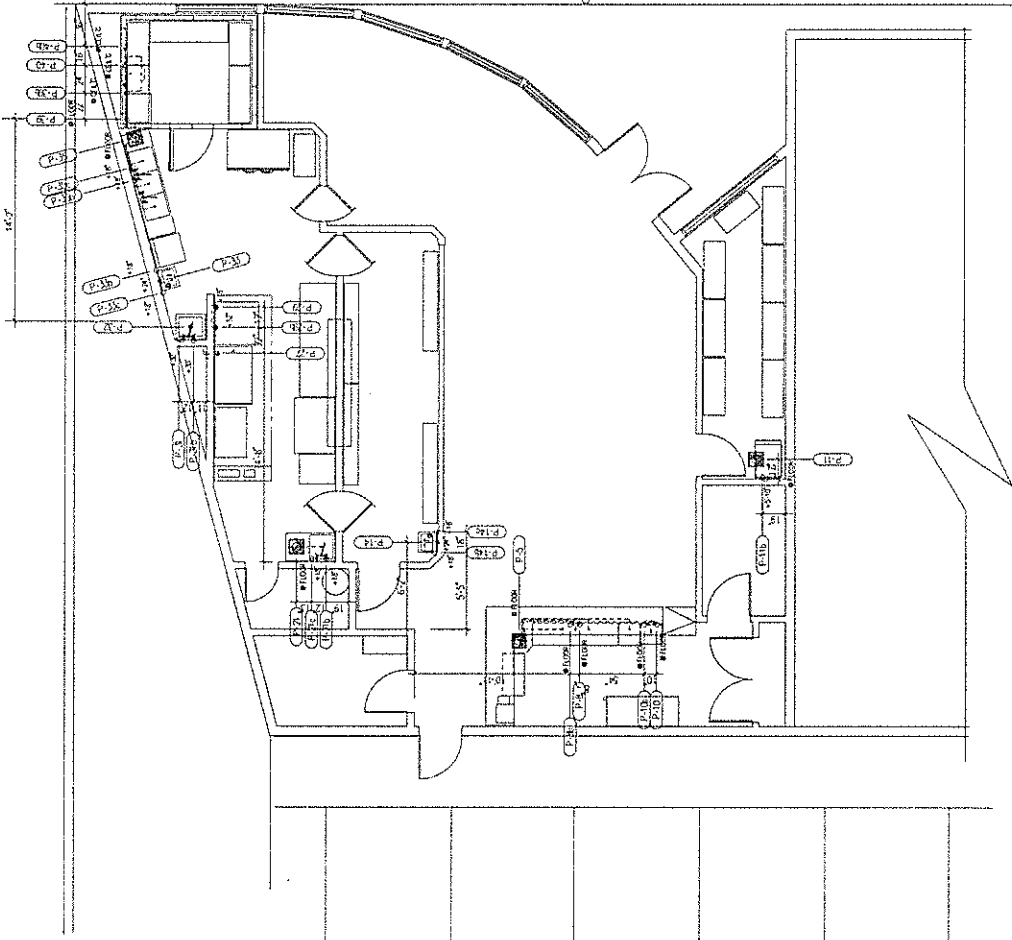

PLUMBING FLOOR PLAN

PLUMBER SHALL INSTALL AUTOMATIC SHUT-OFF VALVE FOR FUEL GAS VALVE SHALL BE SOLENOID TYPE WIRED TO FIRE EXTINGUISHER

52078

IT IS THE INTENTION OF THIS PLAN TO SHOW UTILITY REQUIREMENTS AND CONNECTION POINTS. DO NOT USE FOR ROUGHING-IN LOCATIONS. FOR ACTUAL ROUGHING-IN LOCATIONS REFER TO THE SHOP DRAWINGS PROVIDED BY THE KITCHEN EQUIPMENT CONTRACTOR.

INDIRECT WASTE LINES REQUIRED FOR STANDARD AND/OR FABRICATED ITEMS OF KITCHEN EQUIPMENT SHALL BE FURNISHED, INSTALLED AND EXTENDED TO DRAIN POSITIONS BY THE KITCHEN EQUIPMENT CONTRACTOR, EXCEPT FOR SINKS.

WATER INLET FITTINGS AND VALVE FOR THE SOLED DISHABLE TROUGHS SHALL BE FURNISHED AND INSTALLED BY THE KITCHEN EQUIPMENT CONTRACTOR PLUMBING CONTRACTOR SHALL PROVIDE COLD WATER SERVICE, ALL INTERCONNECTING PIPING, VACUUM BREAKERS AND MAKE FINAL CONNECTIONS.

THE KITCHEN EQUIPMENT CONTRACTOR TO PROVIDE ALL EQUIPMENT FROM, INCLUDING FAUCETS, SINK WASTES AND SINK FAUCETS AT KETTLES AND RANGES, ALL TO BE INSTALLED BY THE PLUMBING CONTRACTOR.

ALL HORIZONTAL PIPING LINES CONNECTED AND EXTENDED FROM EQUIPMENT SHALL BE RUN AT THE HIGHEST POSSIBLE ELEVATION AND NOT LESS THAN 6" ABOVE THE FINISHED FLOOR TO PROVIDE ADEQUATE CLEARANCE FOR CLEANING. AT WALL OR COLUMN LOCATIONS, PIPING ROUGH-INS SHOULD BE STUBBED UP IN WALLS WHEREVER POSSIBLE.

COLD AND HOT WATER AT DISPOSER TO CONNECT TO MIXING VALVE AT 33"-AFF. THEN, FROM MIXING VALVE BACK INTO WALL WITH 3/4" PIPE TO HOSE REEL AT 84"-AFF. TEE COLD WATER TO DISPOSER BEFORE CONNECTING TO MIXING VALVE.

REVISIONS

NO.	DATE	BY

DESERT DESIGNS
KITCHEN & BAR DESIGN
 45775 GORTLE DR. # 9
 PALM SPRINGS, CA 92260
 P: 951-445-3327
 F: 760-365-4889

CATHEDRAL CITY, CALIFORNIA


BEYOND BALISAGE

PROJECT


DRAWN BY: MSJ
 CHECKED BY: MSJ
 DATE: 11-05-17
 SCALE: 1/4" = 1'-0"
 JOB NO.: 88001
 SHEET

K-6


ELEVATION PLAN

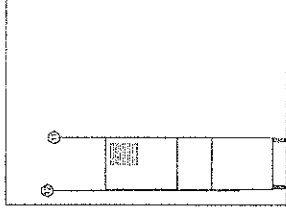


ELEVATION D
 1/2" = 1'-0"

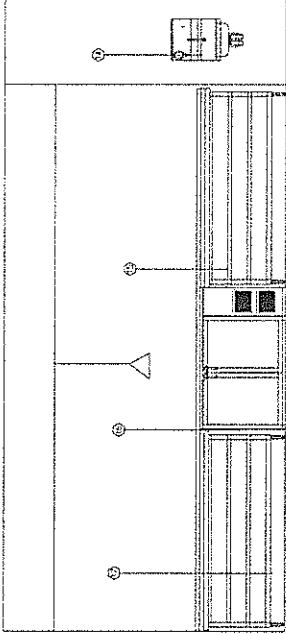


ELEVATION C
 1/2" = 1'-0"

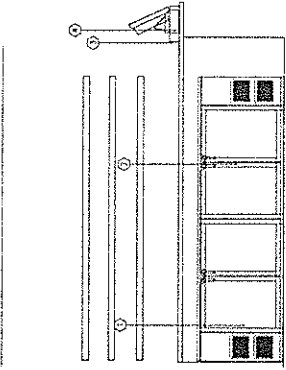


ELEVATION B
 1/2" = 1'-0"

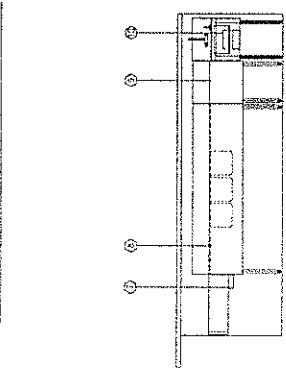


ELEVATION A
 1/2" = 1'-0"

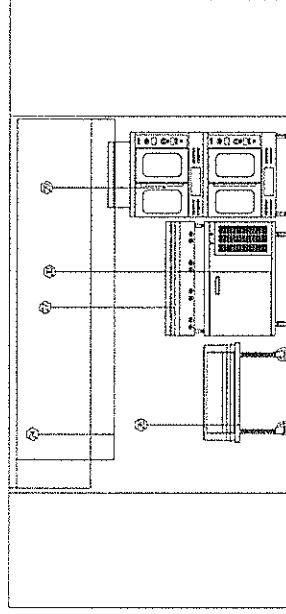


ELEVATION G
 1/2" = 1'-0"

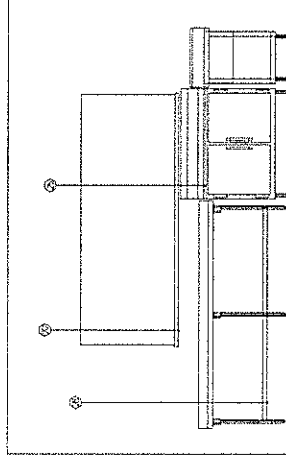


ELEVATION F
 1/2" = 1'-0"

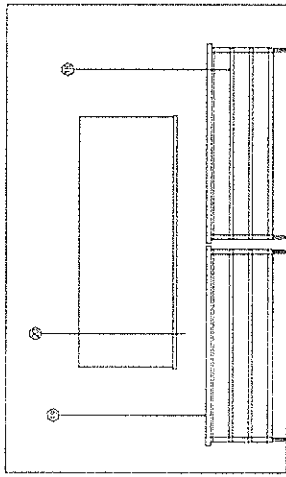

ELEVATION E
 1/2" = 1'-0"

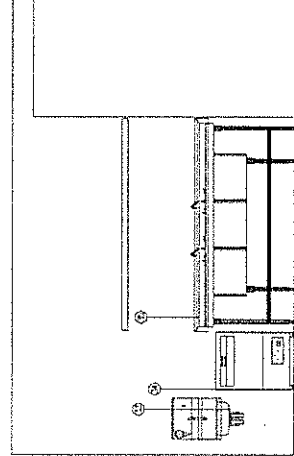

ELEVATION I
 1/2" = 1'-0"

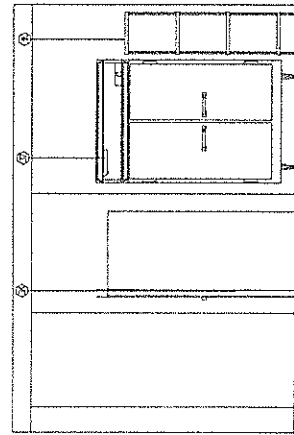

ELEVATION H
 1/2" = 1'-0"


REVISIONS		
NO.	DATE	BY

DESERT DESIGNS
 ARCHITECTS & INTERIORS
 15111 N. GARDEN AVENUE
 SUITE 100
 PALM DESERT, CA 92260
 TEL: 760-333-0321
 FAX: 760-333-0322

CAVENDISH GYM, CALIFORNIA

BEYOND BALISAGE

PROJECT	
DESIGNED BY:	MD
CHECKED BY:	HCL
DATE:	05-25-17
SCALE:	1/4" = 1'-0"
JOB NO.:	18001
SHEET	3D-1

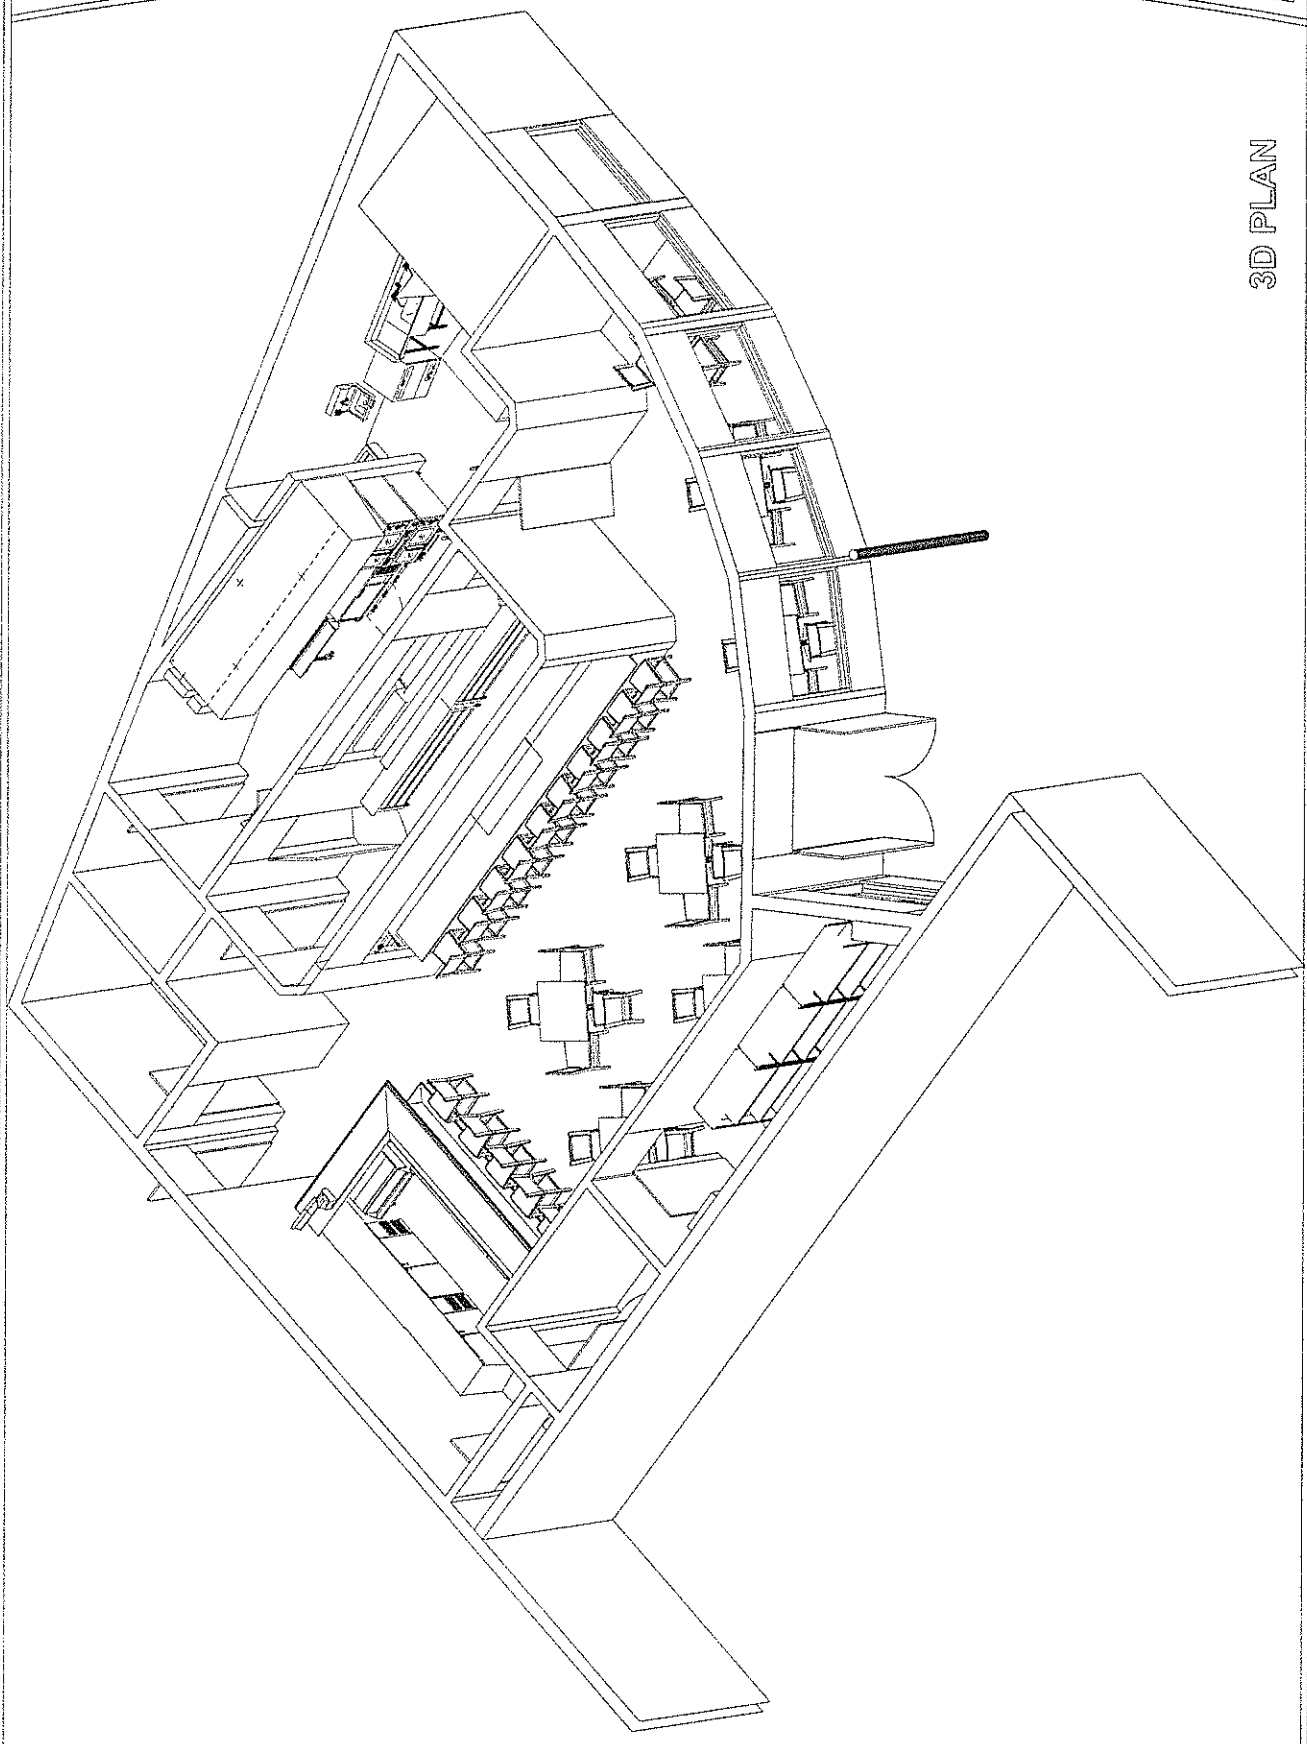

3D PLAN

REVISIONS		
NO.	DATE	BY


DESERT DESIGNS
 KITCHEN & BAR DESIGN
 4577 W. CENTRAL AVENUE
 PALM SPRINGS, CA 92262
 C: 949-945-5552 F: 760-565-6889

CATHEDRAL CITY, CALIFORNIA

BEYOND BALISAGE

PROJECT	
DRAWN BY: MSJ	CHECKED BY: MSJ
DATE: 11-04-17	SCALE: 1/4"=1'-0"
JOB NO.: B0091	SHEET
RC-1	

REFLECTIVE CEILING PLAN

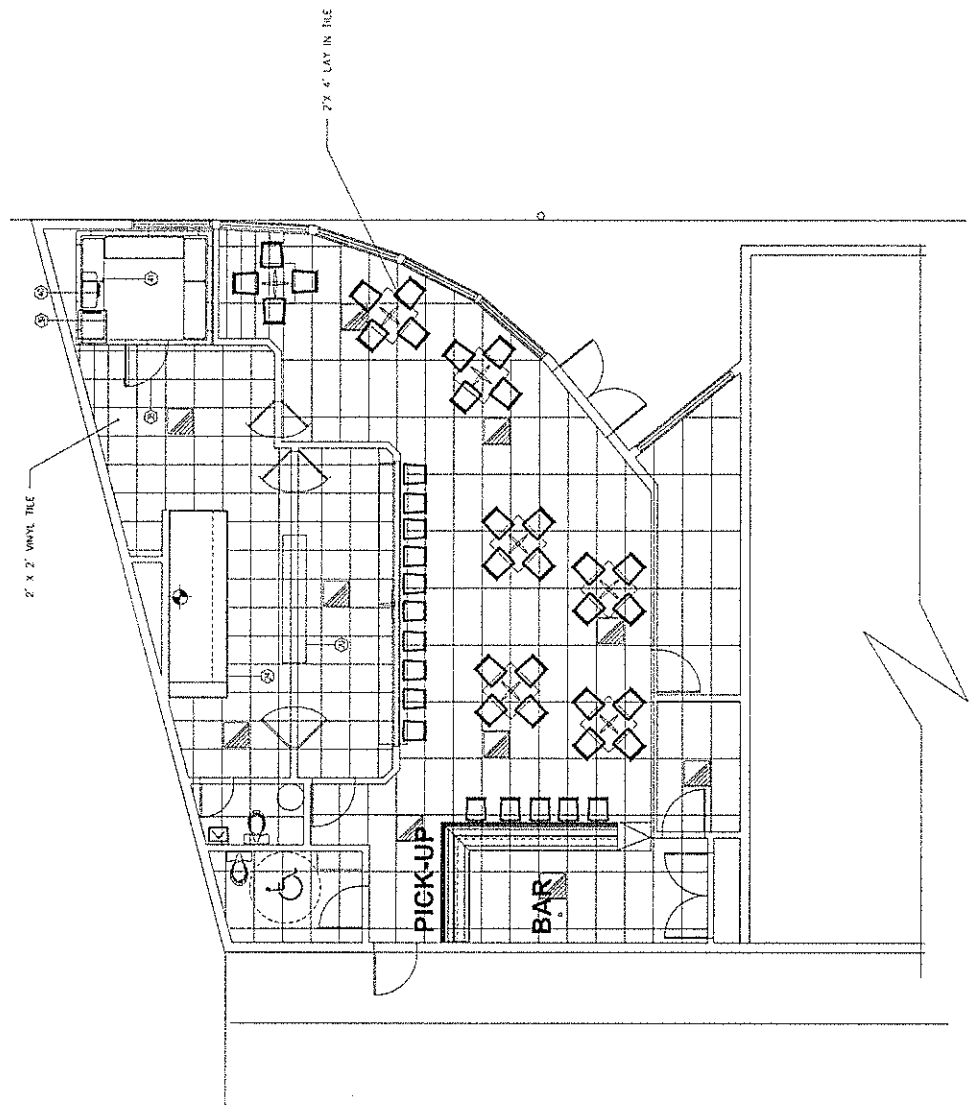

REVISIONS		
NO.	DATE	BY

DESERT DESIGNS
 KITCHEN & BATH DESIGN
 11100 W. CENTRAL AVENUE, SUITE 100
 PALM DESERT, CA 92260
 P: 949-445-3582
 F: 949-445-4888

CATHEDRAL CITY, CALIFORNIA

BEYOND BALISAGE

PROJECT	
DRAWN BY: MSJ	CHECKED BY: MSJ
DATE: 10-3-17	SCALE: 3/4"=1'-0"
JOB NO: DD001	SHEET
D-1	

DEMO PLAN

